


SYMBOLS LEGEND

RCP	ELECTRIC
EXHAUST VENT	DATA OUTLET
CEILING MOUNTED LIGHT FIXTURE	TELEPHONE JACK
RECESSED CAN LIGHT	ELECTRIC SWITCH
INDIVIDUAL FLOOR LAV-IN FIXTURE 4 BULB	CABLE TELEVISION OUTLET
INDIVIDUAL FLOOR HANGING FIXTURE 2 BULB	DUPLEX RECEPTACLE OUTLET
INDIVIDUAL FLOOR FLUSH MOUNT FIXTURE 4 BULB	SPECIAL PURPOSE CONNECTION OR OUTLET
CAMERA	QUADRIPLUX RECEPTACLE OUTLET
MOTION DET.	FLOOR DUPLEX RECEPTACLE OUTLET
SUPPLY VENT	ELECTRIC PANEL
SUPPLY VENT	ELECTRIC METER
RETURN VENT	BUTTON SWITCH
RETURN VENT	DISCONNECT SWITCH
TRACK LIGHTING UNIT FIXTURE	GROUND/FLOOR LIGHT
WALL-MOUNTED LIGHT FIXTURE	
EMERGENCY EXIT SIGN	
EMERGENCY EXIT LIGHT	
EMERGENCY EXIT LIGHT W/ SIGN	
FLOOD LIGHT	
PHOTO CELL	
CEILING FAN	
CEILING FAN W/ LIGHT KIT	
SPEAKER	
	FIRE EXTINGUISHER
	FIRE PULL
	FIRE ALARM (HORN/STROBE)
	SMOKE DETECTOR
	SPRINKLER HEAD
	MEP
	THERMOSTAT
	FLOOR DRAIN
	VALVE
	HOSE BIB
	ELEVATIONS
	FLOOR / GROUND ELEVATION
	CEILING HEIGHT AND TRIM
	7'-0" ABOVE FLOOR BELOW
	WITH 6" CROWN MOULDING



AB-1

	EXHAUST VENT		DATA OUTLET
	CEILING MOUNTED LIGHT FIXTURE		TELEPHONE JACK
	RECESSED CAN LIGHT		ELECTRIC SWITCH
	INDIVIDUAL FLOOR LAY-IN FUTURE 4 BULD		CABLE TELEVISION OUTLET
	INDIVIDUAL FLOOR FINANCING FUTURE 2 BULD		DUPLEX RECEPTACLE OUTLET
	INDIVIDUAL FLOOR FLUSH MOUNT FUTURE 4 BULD		SPECIAL PURPOSE CONNECTION OR OUTLET
	CAMERA		QUADRIPLUX RECEPTACLE OUTLET
	MOTION DET.		FLOOR DUPLEX RECEPTACLE OUTLET
	SUPPLY VENT		ELECTRIC PANEL
	SUPPLY VENT		ELECTRIC METER
	RETURN VENT		BUTTON SWITCH
	RETURN VENT		DISCONNECT SWITCH
	TRUCK LIGHTING LIGHT FIXTURE		GROUND FLOOR LIGHT
	WALL-MOUNTED LIGHT FIXTURE		
	EMERGENCY EXIT SIGN		FIRE EXTINGUISHER
	EMERGENCY EXIT LIGHT		FIRE FILL
	EMERGENCY EXIT LIGHT (N) SIGN		FIRE ALARM (HORN/SKTBOD)
	FLOOD LIGHT		SMOKE DETECTOR
	PG 18		* SPRINKLER HEAD
	PHOTO CELL		
	CEILING FAN		
	CEILING FAN W LIGHT KIT		
	SPEAKER		

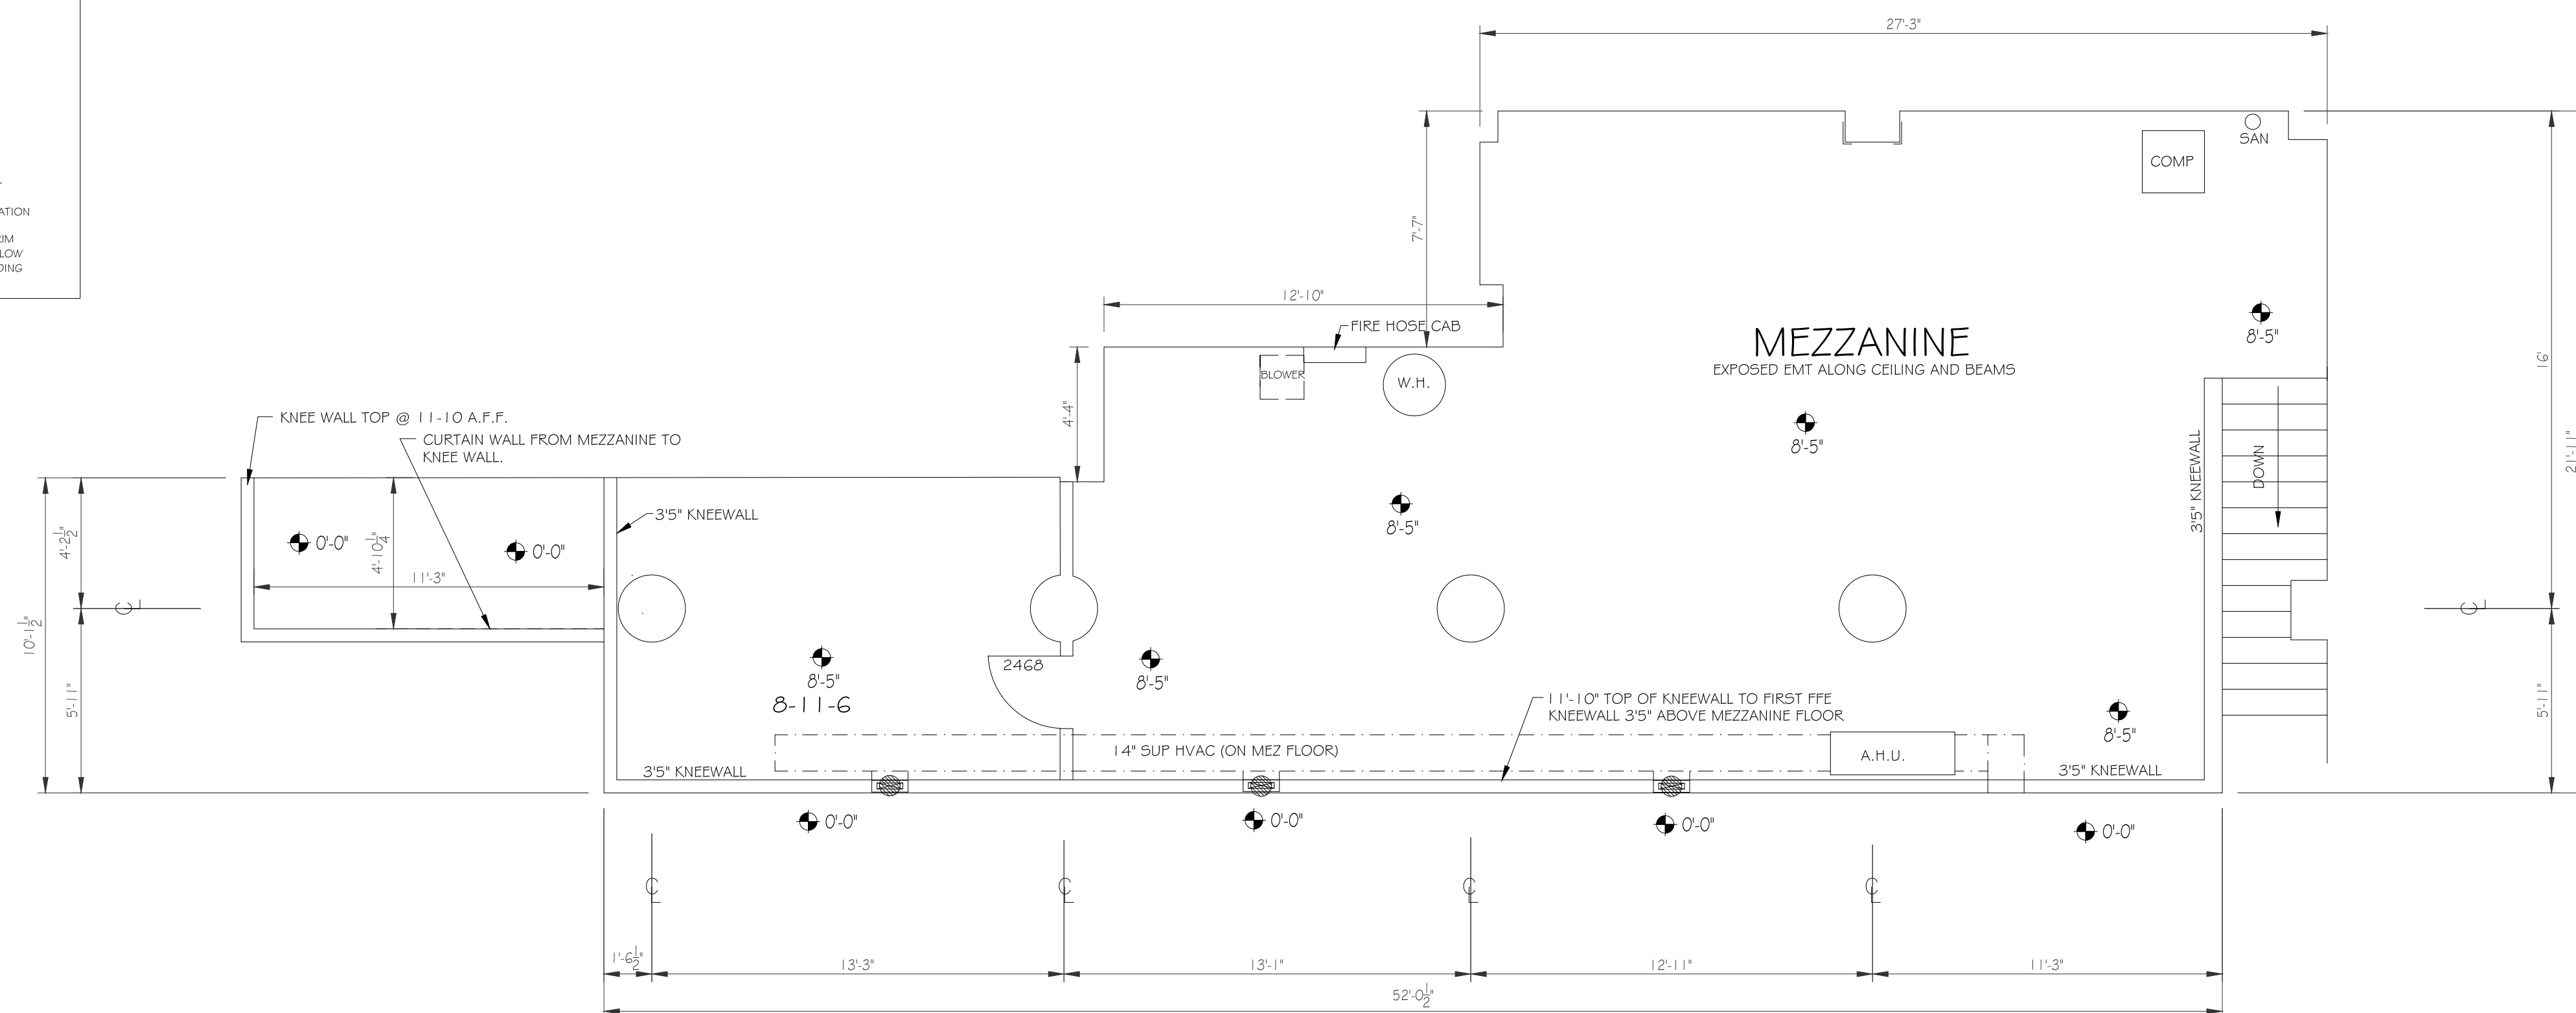

MEZZANINE PLAN $\frac{1}{4}'' = 1'-0''$

A DIVISION OF:

© 2016 AEC CONSULTANTS INC.

San Francisco, CA 94104


01		
NO.	ISSUES REVISIONS	DATE
		SHEET TITLE
SECOND FLOOR PLAN		
XX		PROJECT MANAGER
HL		PROJECT DIRECTOR
XX.XX.XX		PROJECT NUMBER
AS NOTED		SCALE
XX		DRAWN BY
		SHEET NUMBER

SECOND FLOOR PLAN

XX	PROJECT MANAGER
HL	PROJECT DIRECTOR
XX.XX.XX	PROJECT NUMBER
AS NOTED	SCALE
XX	DRAWN BY
	SHEET NUMBER

AB-2


ELECTRIC

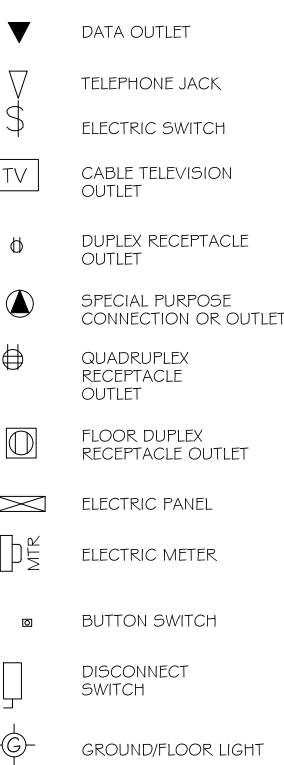

- FIRE EXTINGUISHER
- FIRE PULL
- FIRE ALARM (HORN/SPEAKER)
- SMOKE DETECTOR
- SPRINKLER HEAD

	THERMOSTAT
	FLOOR DRAIN
	VALVE
	HOSE BIB

 19'-0" FLOOR / GROUND ELEVATION
 7-2-6 CEILING HEIGHT AND TRIM
 7'-2" ABOVE FLOOR BELOW
 WITH 6" CROWN MOULDING

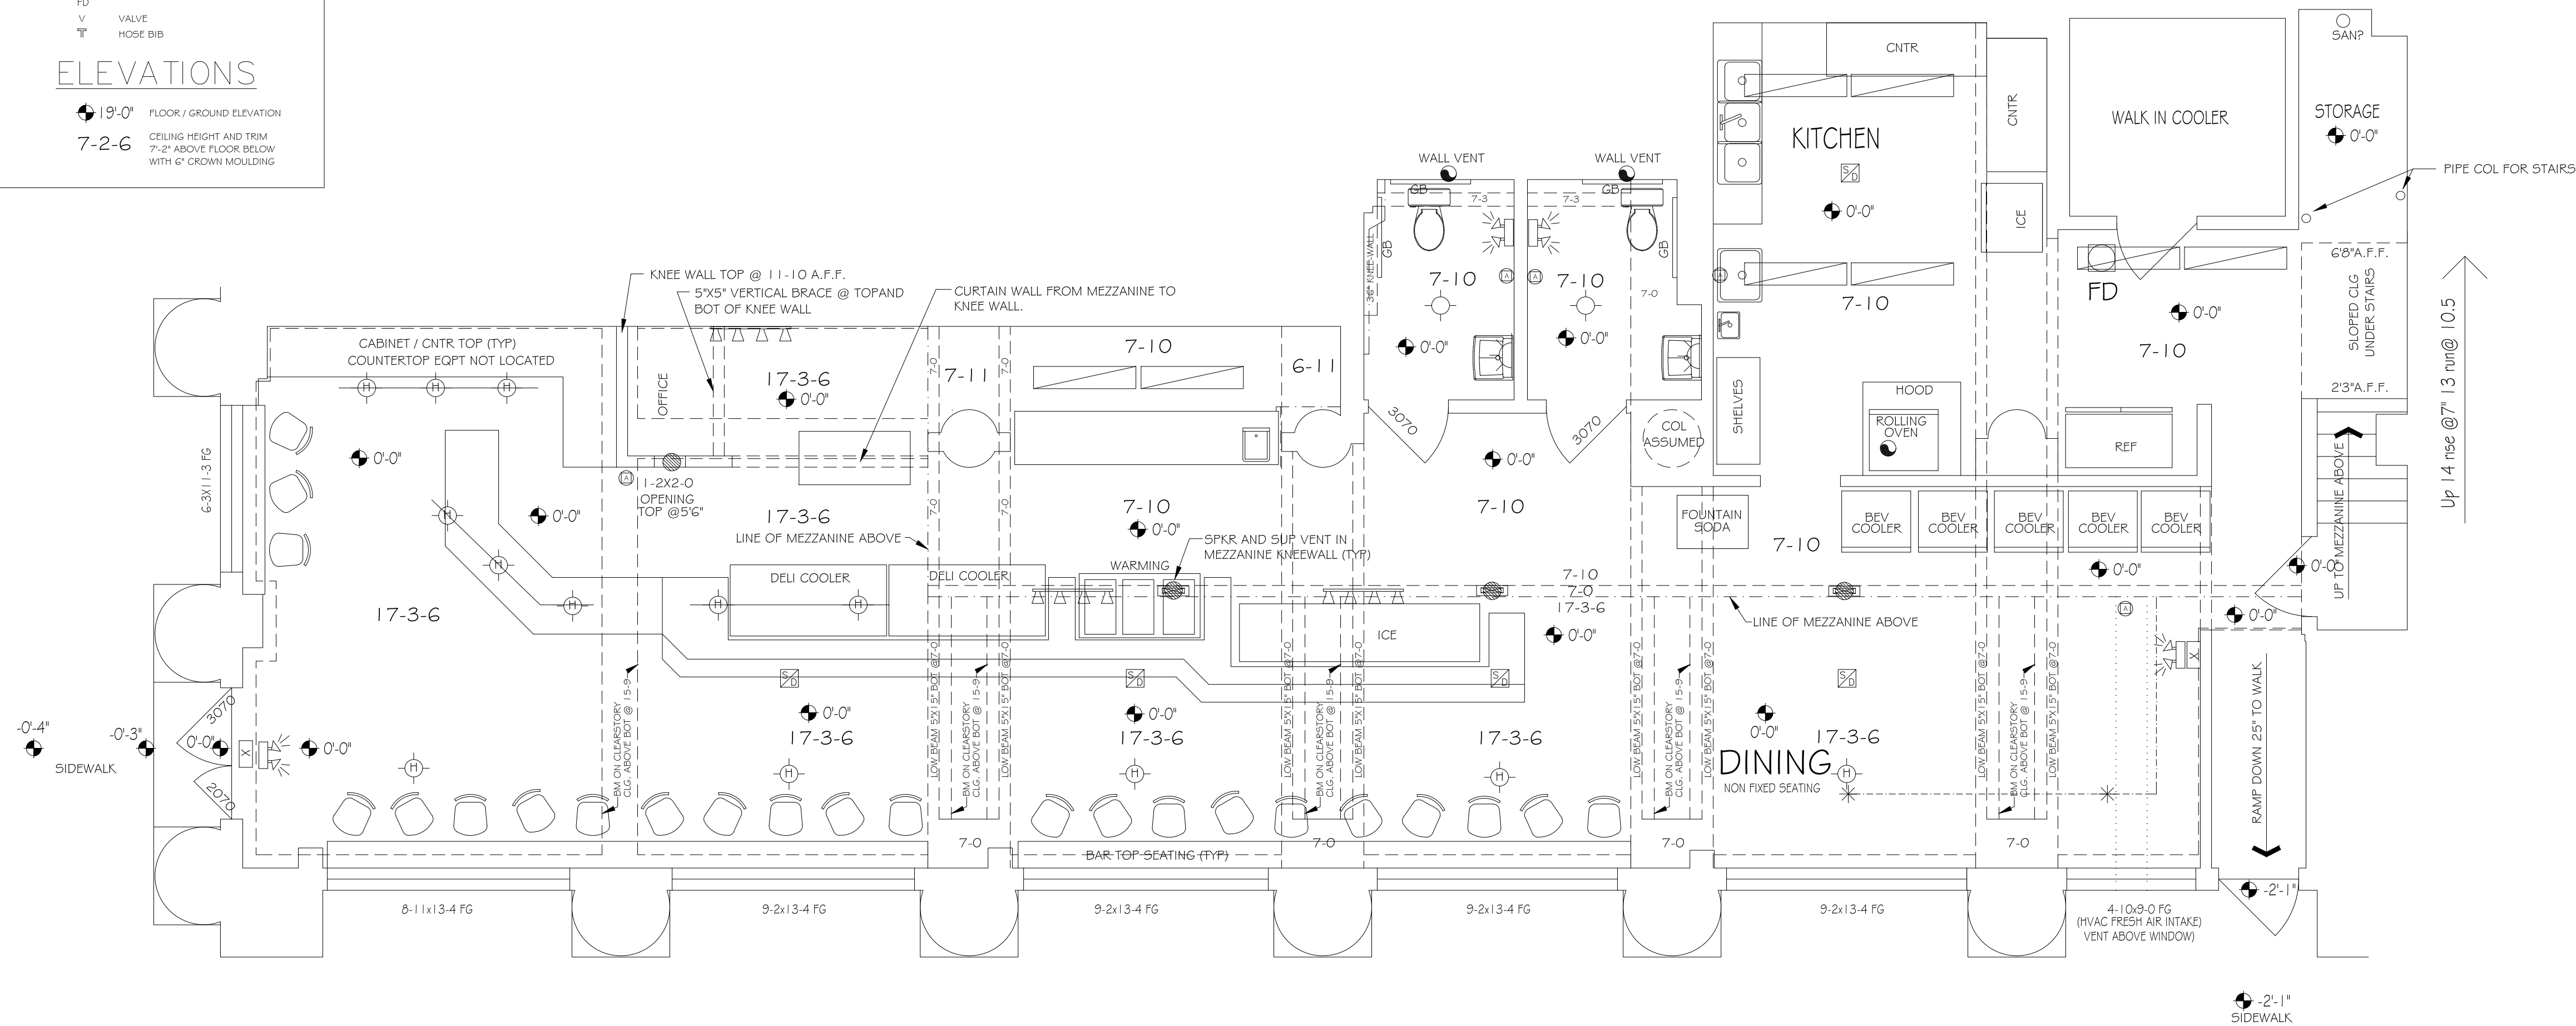

FIRST FLOOR PLAN WITH RCP $\frac{1}{4}" = 1'-0"$
ALL CEILINGS APPEAR TO BE PLASTER


© 2016 AEC CONSULTANTS INC

AS BUILT DOCUMENTATION

Diller's Delicatessen
348 Pine St
San Francisco, CA 94104

O1	
No.	ISSUES REVISIONS DATE
SHEET TITLE	
FIRST FLOOR REFLECTED CEILING PLAN	
XX	PROJECT MANAGER
HL	PROJECT DIRECTOR
XX.XX.XX	PROJECT NUMBER
AS NOTED	SCALE
XX	DRAWN BY
SHEET NUMBER	


AB-3

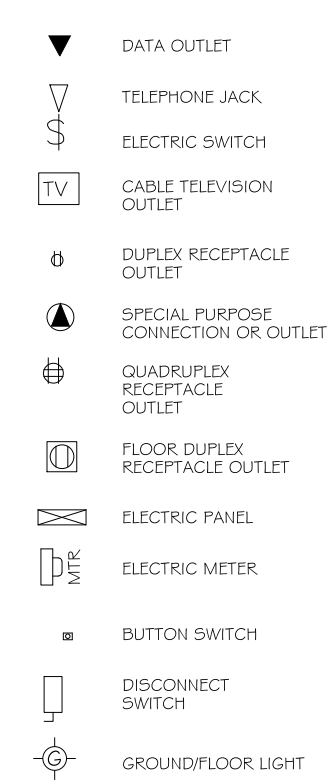ELECTRIC

- FIRE EXTINGUISHER
- FIRE PULL
- FIRE ALARM (HORN/SPEAKER)
- SMOKE DETECTOR
- SPRINKLER HEAD

⊖	THERMOSTAT
FD	FLOOR DRAIN
V	VALVE
T	HOSE BIB

 19'-0" FLOOR / GROUND ELEVATION
 7'-2-6 CEILING HEIGHT AND TRIM
 7'-2" ABOVE FLOOR BELOW
 WITH 6" CROWN MOULDING

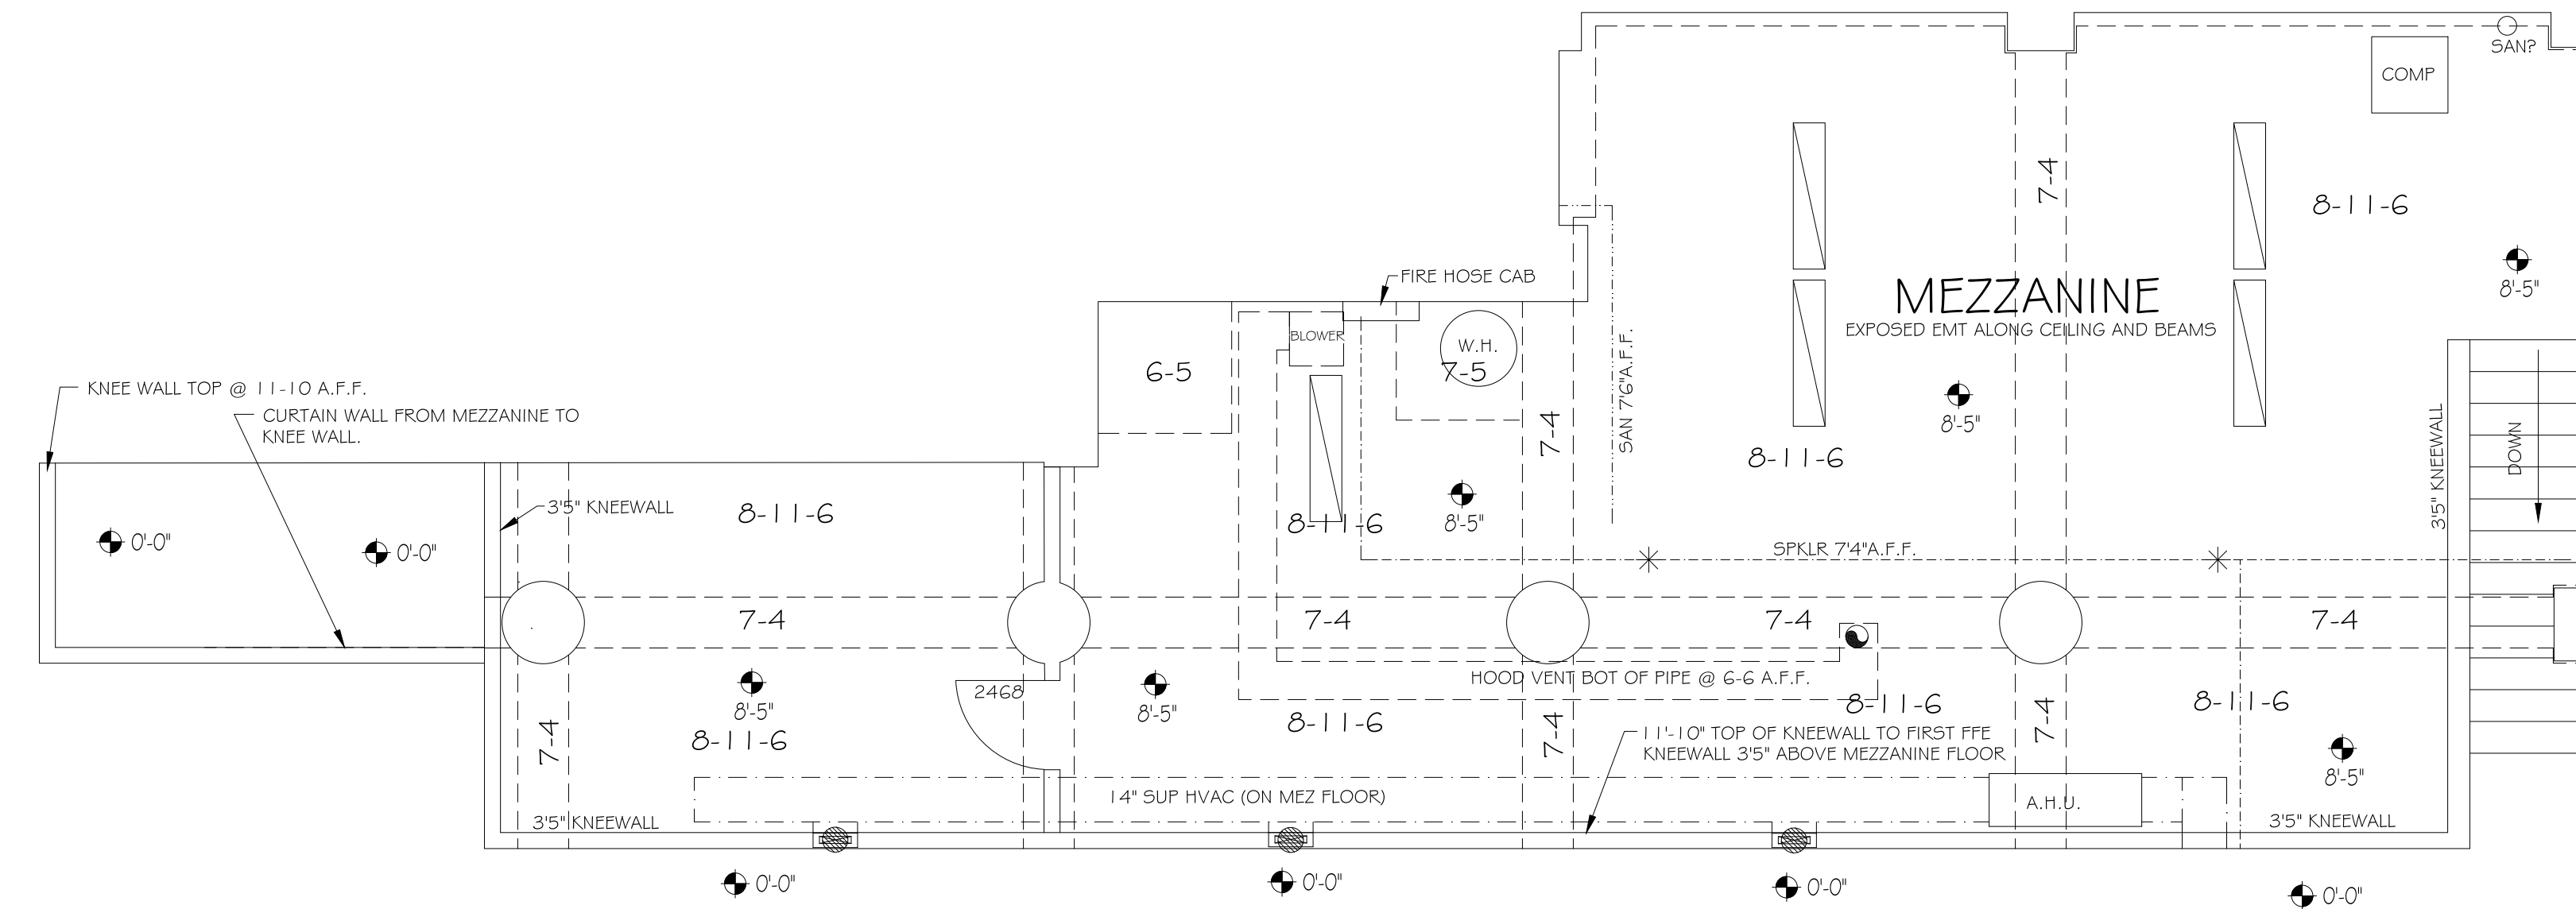

MEZZANINE PLAN WITH RCP $\frac{1}{4}" = 1'-0"$
ALL CEILINGS APPEAR TO BE PLASTER

A DIVISION OF:



© 2016 AEC CONSULTANTS INC

Diller's Delicatessen

**348 Pine St
San Francisco, CA 94104**

O1		
No.	ISSUES REVISIONS	DATE

SECOND FLOOR REFLECTED CEILING PLAN

XX	PROJECT MANAGER
HL	PROJECT DIRECTOR
XX.XX.XX	PROJECT NUMBER
AS NOTED	SCALE
XX	DRAWN BY
	SHEET NUMBER

AB-4