

GUEST ROOM SUMMARY AND LOCATION			
ROOM TYPE A		ROOM TYPE B	ROOM TYPE C
A X05 A - QTY: 10 (305-1205)	A-6 X07 A-6 - QTY: 1 (1407)	B X01 B - QTY: 9 (301-1101)	C X06 C - QTY: 11 (306-1406)
A-M X07 A - QTY: 10 (307-1207)	A-6M X05 A-6 - QTY: 1 (1405)	B-1 X02 B-1 - QTY: 9 (302-1102)	C-1 X08 C-1 - QTY: 11 (308-1408)
A-1 X04 A-1 - QTY: 10 (304-1204)	A-7 X09 A-7 - QTY: 1 (1409)	B-2 X03 B-2 - QTY: 9 (303-1103)	C-2 X10 C-2 - QTY: 11 (310-1410)
A-2 X09 A-2 - ADA - QTY: 6 (409-909)	A-8 X02 A-8 - QTY: 1 (202)	B-3 X11 B-3 - QTY: 11 (311-1411)	C-3 X04 C-3 - QTY: 1 (1404)
A-3 X09 A-3 - QTY: 3 (1009-1209)	A-9 X02 PRES. SUITE A-9 - QTY: 1 (1201/1202)	B-4 X15 B-4 - QTY: 11 (315-1415)	
A-4 X12 A-4 - QTY: 11 (312-1412)	A-10 X02 PRES. SUITE A-10 - QTY: 1 (1401/1402)	B-5 X01 B-5 ADA - QTY: 1 (201)	
A-5 X13 A-5 - QTY: 11 ROOMS (313-1413)	A-11 X09 A-11 - ADA - QTY: 1 (309)	B-6 X03 B-6 - QTY: 2 (1203 & 1403)	
A-5M X14 A-5 - QTY: 11 ROOMS (314-1414)			

SYMBOLS LEGEND

RCP	ELECTRIC	FIRE PROTECTION
EXHAUST VENT CEILING MOUNTED LIGHT FIXTURE CEILING MOUNTED DIRECTIONAL LIGHT RECESSED CAN LIGHT • EYEBALL OR SMALL CAN LIGHT PENDANT LIGHT INDIVIDUAL FLOOR LAY-IN FIXTURE 4 BULB INDIVIDUAL FLOOR HANGING FIXTURE 2 BULB INDIVIDUAL FLOOR FLUSH MOUNT FIXTURE 4 BULB • CAMERA MOTION DET. SUPPLY VENT RETURN VENT SPEAKER	TRACK LIGHT OR VANITY LIGHT HALL-MOUNTED LIGHT FIXTURE EMERGENCY EXIT SIGN EMERGENCY EXIT LIGHT EMERGENCY EXIT LIGHT W/ SIGN LIGHTED STAIR SIGN FLOOD LIGHT PHOTO CELL CEILING FAN CEILING FAN W/ LIGHT KIT 7-2-6 CEILING HEIGHT AND TRIM 7'-2" ABOVE FLOOR BELOW WITH 6" CROWN MOULDING. NOTE: ALL CEILINGS NOT LABELED ARE PLASTER CEILINGS SHOWN WITH A GRID ARE LAY IN ACOUSTICAL TILE. JUNCTION BOX	FIRE EXTINGUISHER FIRE PULL FIRE ALARM (HORN/SET/CODE) SMOKE DETECTOR SMOKE ALARM SPEAKER * SPRINKLER HEAD CEILING MOUNT □ SPRINKLER HEAD WALL MOUNT
	DATA OUTLET TELEPHONE JACK ELECTRIC SWITCH CABLE TELEVISION OUTLET DUPLEX RECEPTACLE OUTLET SPECIAL PURPOSE CONNECTION OR OUTLET QUADPLEX RECEPTACLE OUTLET FLOOR DUPLEX RECEPTACLE OUTLET ELECTRIC PANEL ELECTRIC METER BUTTON SWITCH DISCONNECT SWITCH GROUND/FLOOR LIGHT KEY PAD	MISC ○ THERMOSTAT ■ FLOOR DRAIN - VALVE + HOSE BIB I WATER SUPPLY ☐ SUSPENDED GAS HEATER ● BOLLARD

© 2016 AEC CONSULTANTS INC.

ARCHITECTURAL AS BUILT
HOTEL INDIGO
1244 N DEARBORN STREET CHICAGO, IL 60614

01	100% SUBMISSION	
NO.	ISSUES REVISIONS	DATE
		SHEET TITLE
HL		PROJECT MANAGER
HL		PROJECT DIRECTOR
9-2-16-1		PROJECT NUMBER
AS NOTED		SCALE
CL		DRAWN BY
		SHEET NUMBER
L-1		



1244 N DEARBORN SIREI CHICAGO, IL 60610



 
X05

A - QTY: 10 (305-1205)




X07

A - QTY: 10 (307-1207)




X04

 A-1 - QTY: 10 (304-1204)



X09

 A-2 - ADA - QTY: 6 (409-909)



X09

A-3 - QTY: 3 (1009-1209)



 
X12

A-4 - QTY: 11 (312-1412)



X13

A-5 - QTY: 11 ROOMS (313-1413)








X14

A-5 - QTY: 11 ROOMS (314-1414)


ROOM LAYOUTS 1/4"=1'-0"

ABR-1

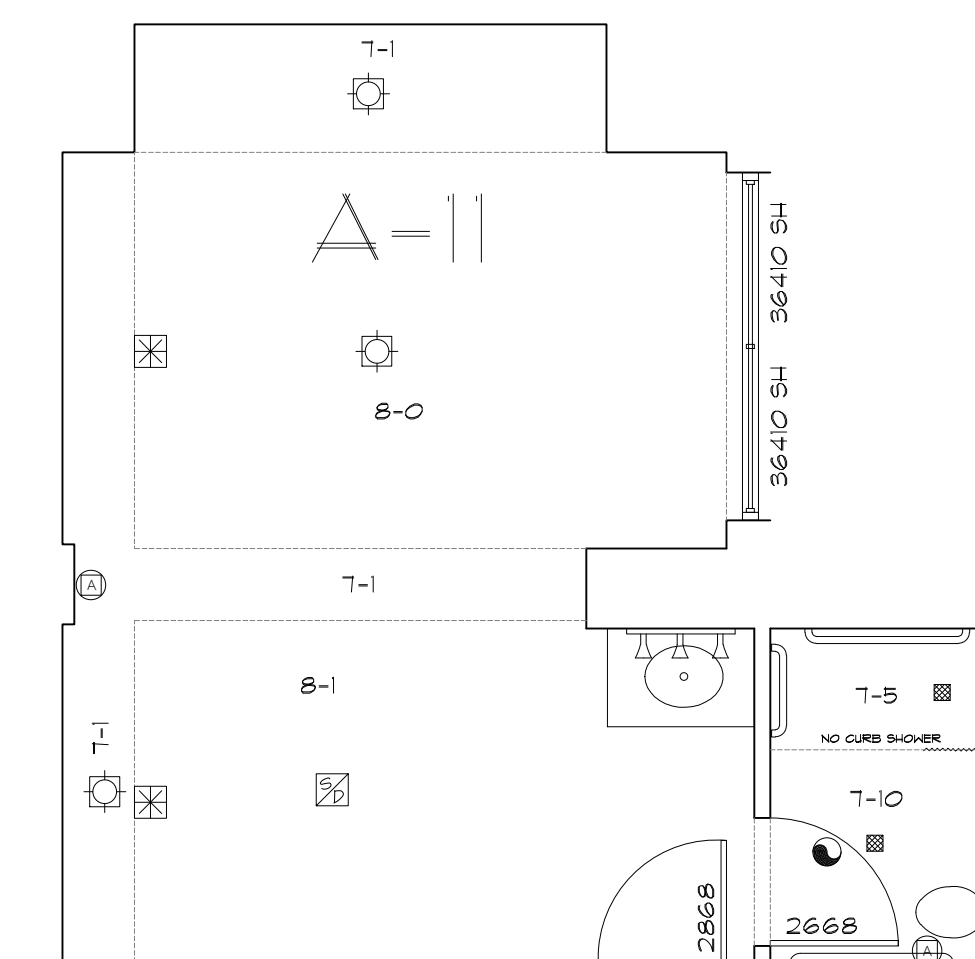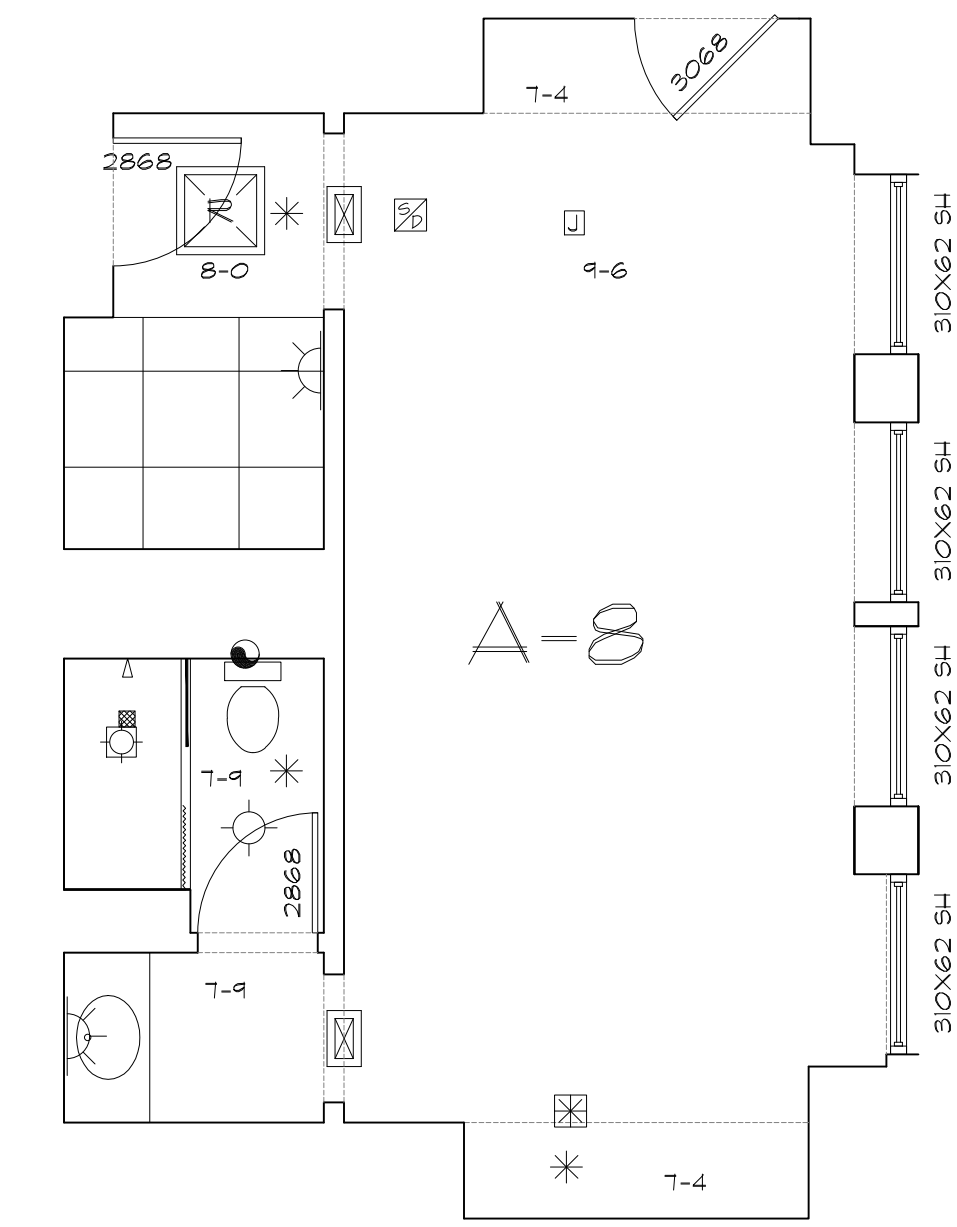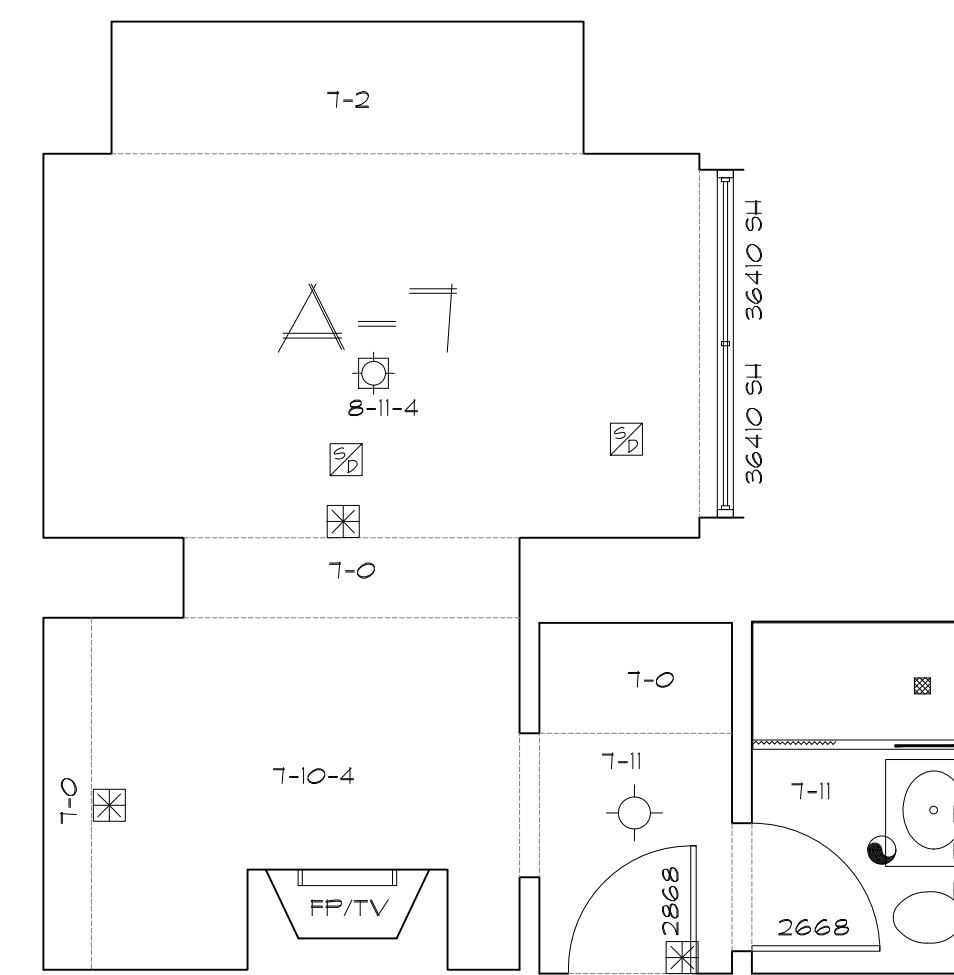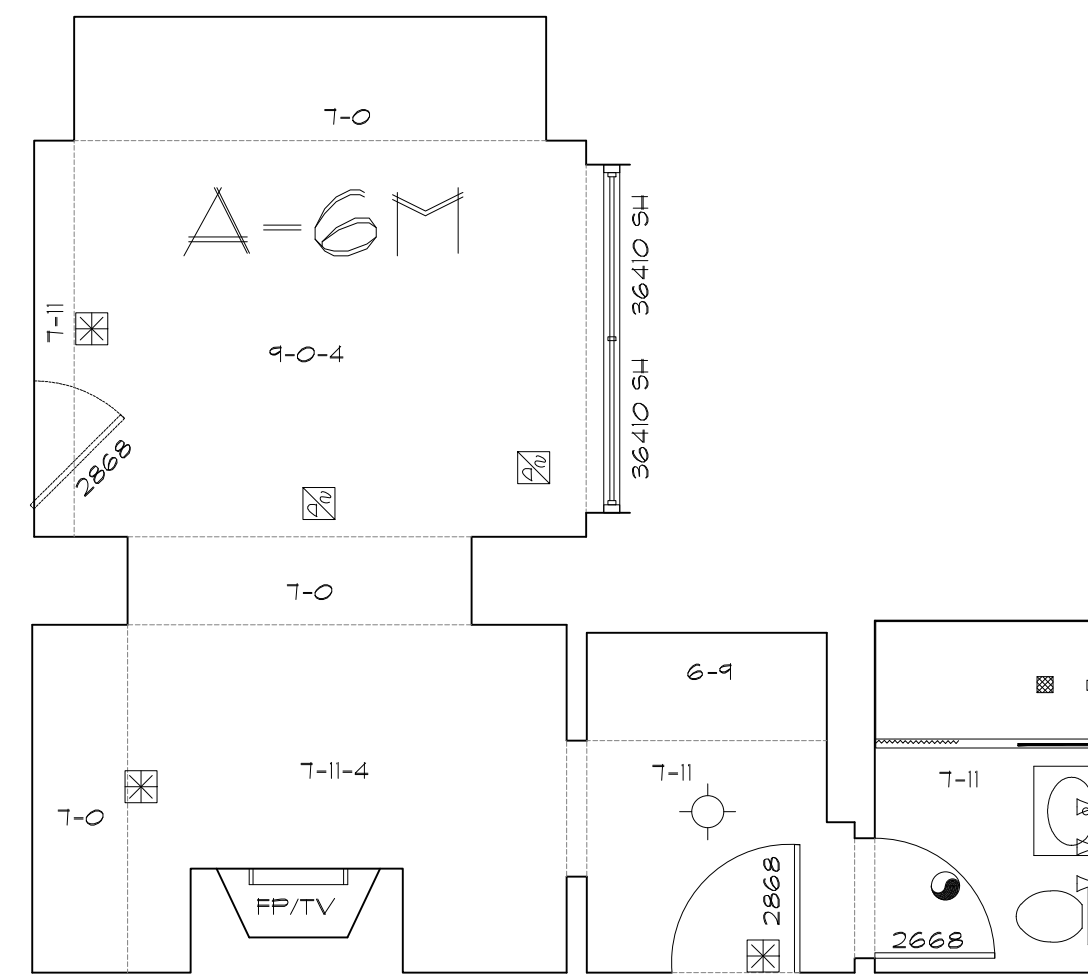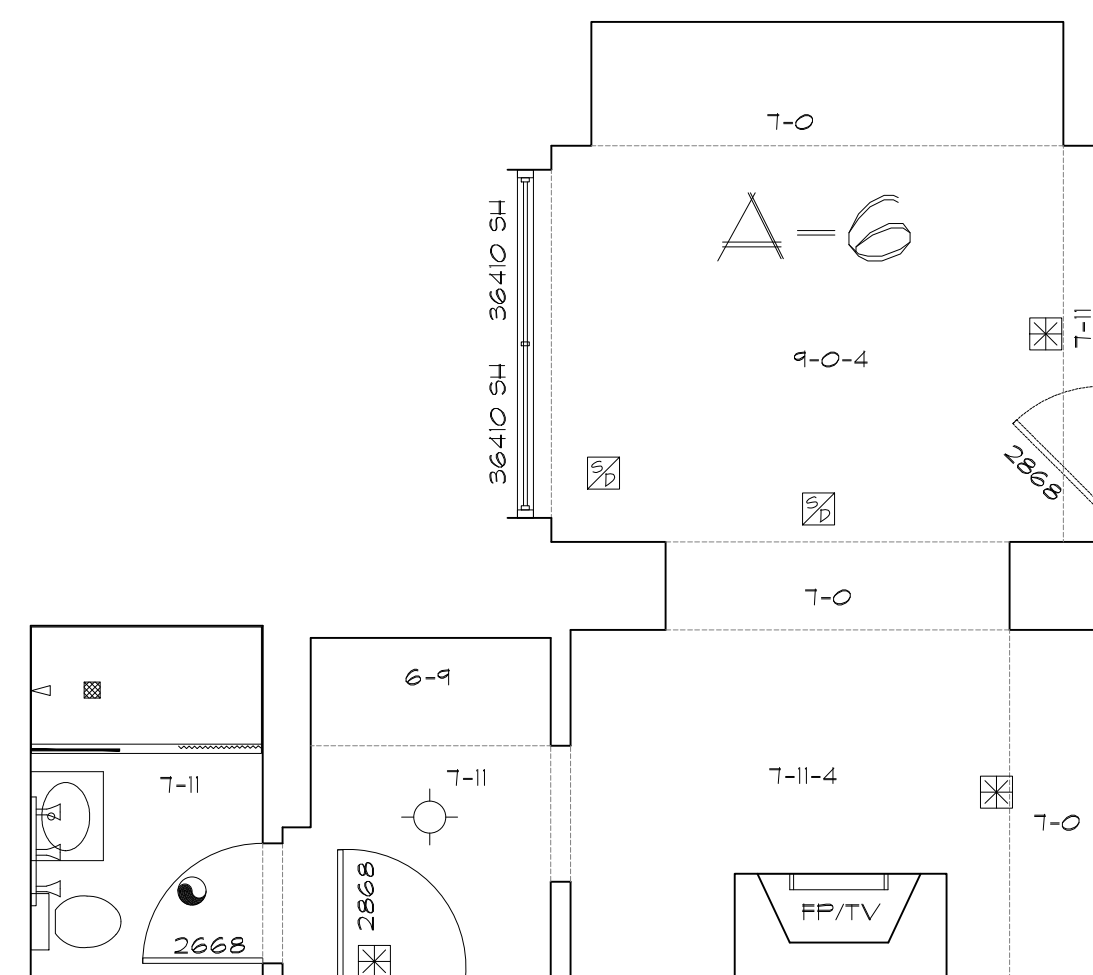


ARCHITECTURAL AS BUILT
HOTEL INDIGO
1244 N DEARBORN STREET CHICAGO, IL 60610

01	100% SUBMISSION	
NO.	ISSUES REVISIONS	DATE
		SHEET TITLE
HL		PROJECT MANAGER
HL		PROJECT DIRECTOR
9-2-16-1		PROJECT NUMBER
AS NOTED		SCALE
CL		DRAWN BY
		SHEET NUMBER
ABR-2		

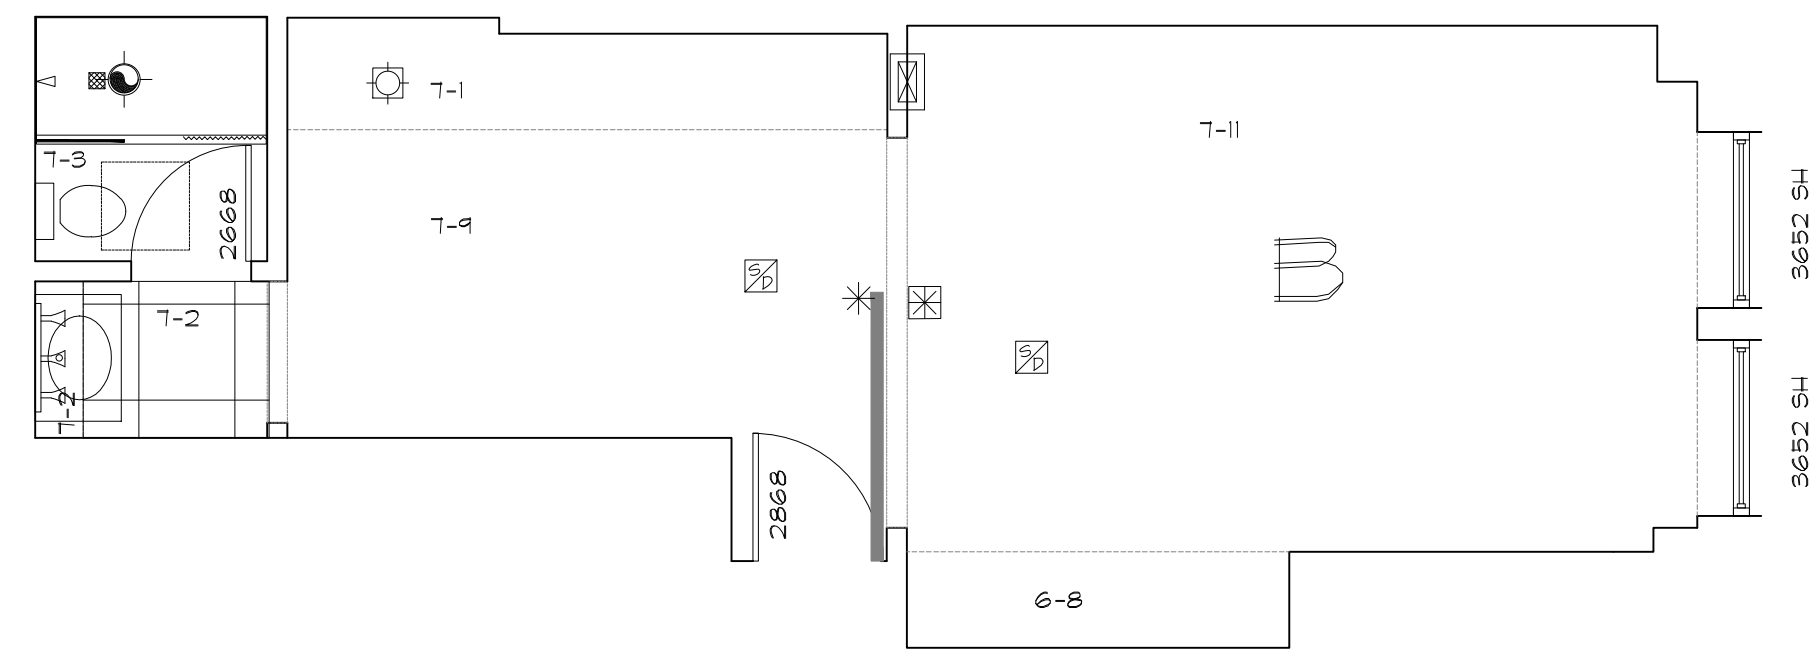


B
X01

B - QTY: 9 (301-1101)

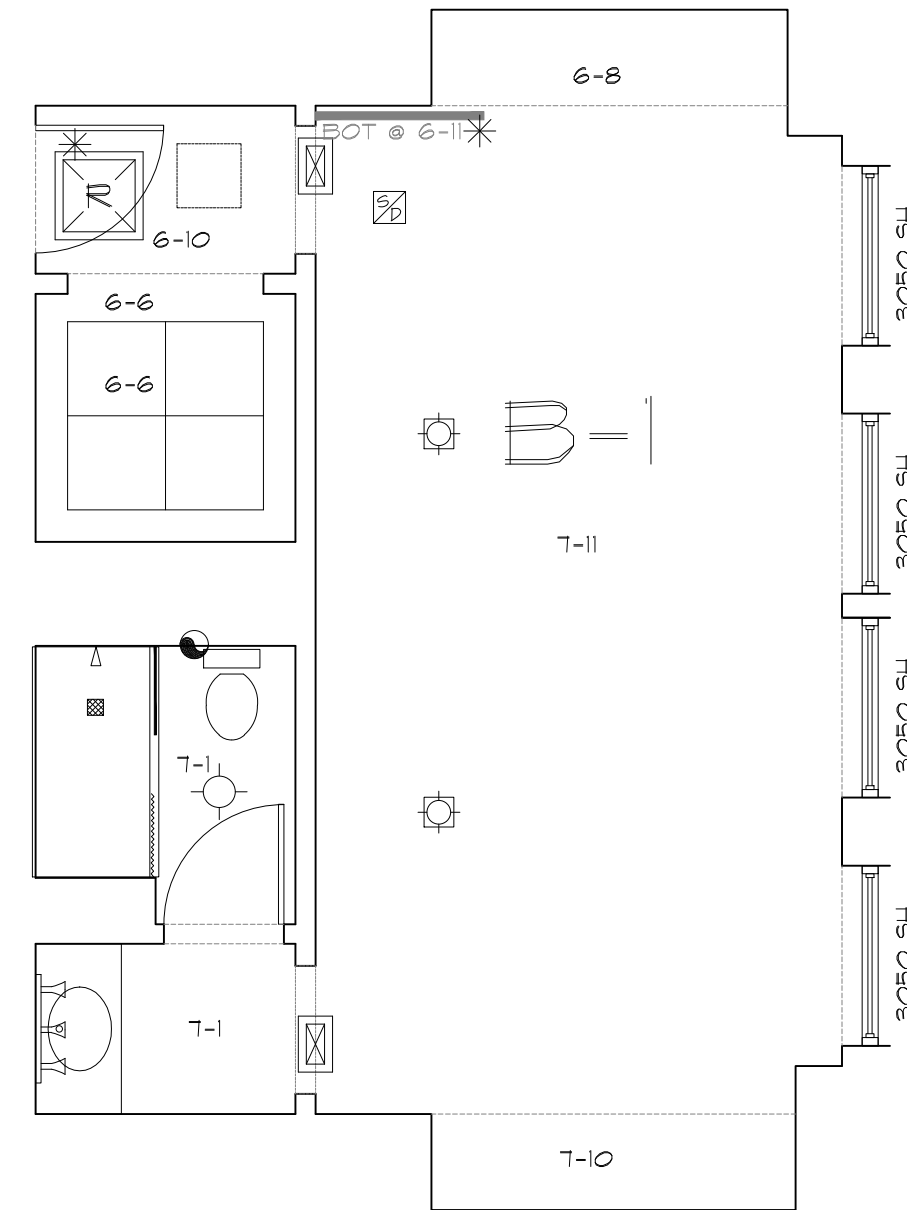


B-1
X02

B-1 - QTY: 9 (302-1102)

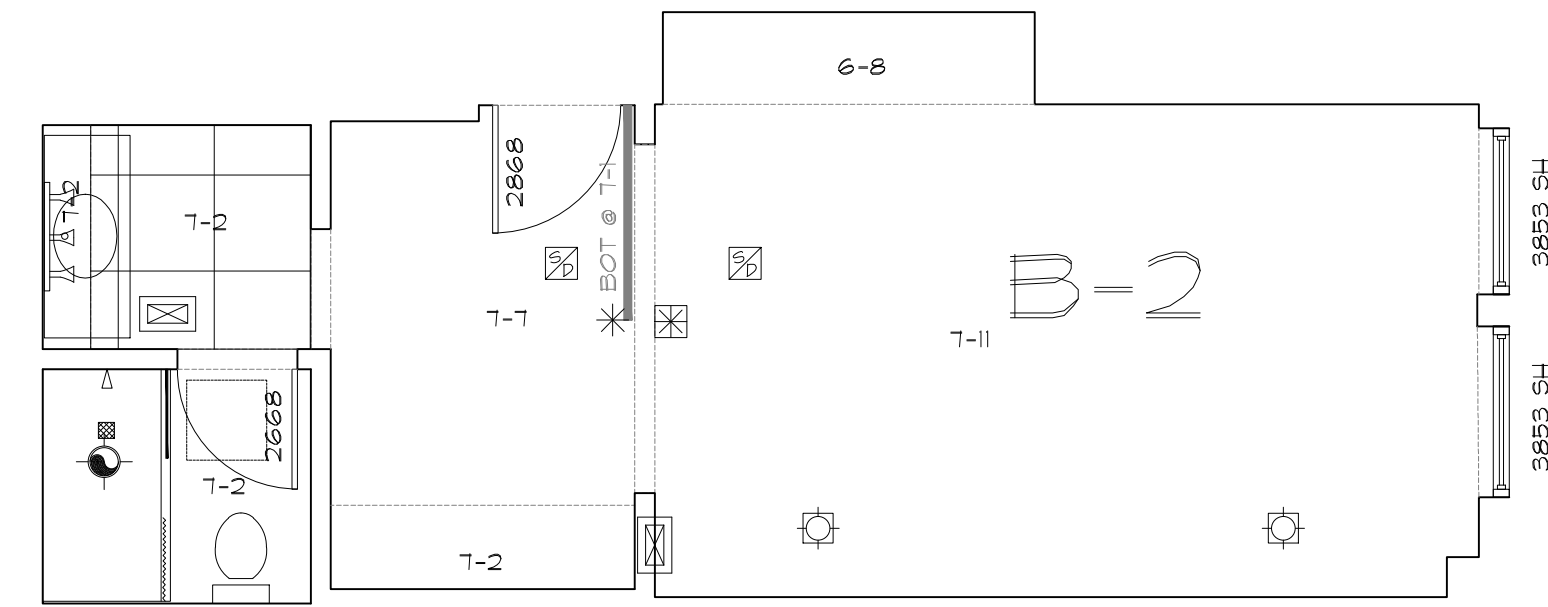


B-2
X03

B-2 - QTY: 9 (303-1103)

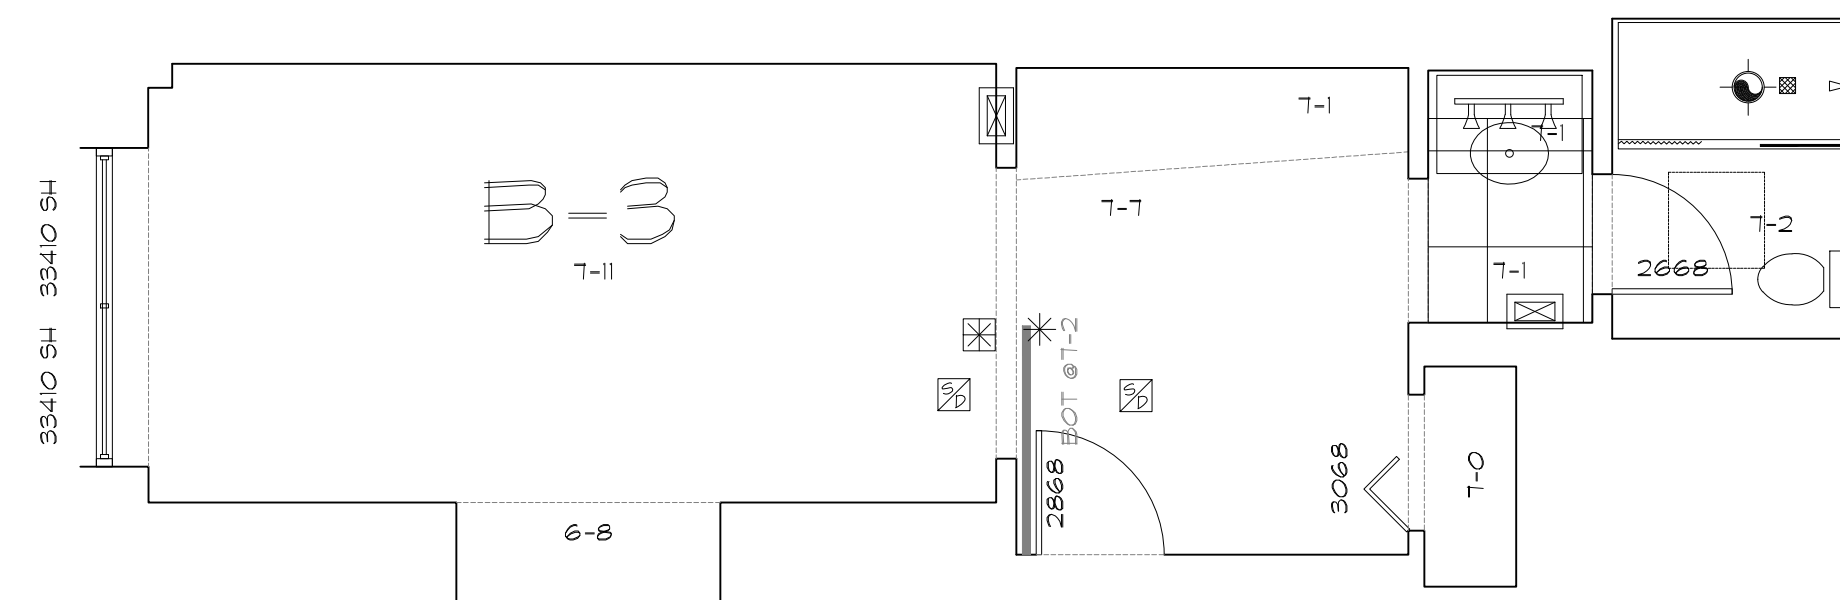

B-3
X11

B-3 - QTY: 11 (311-1411)

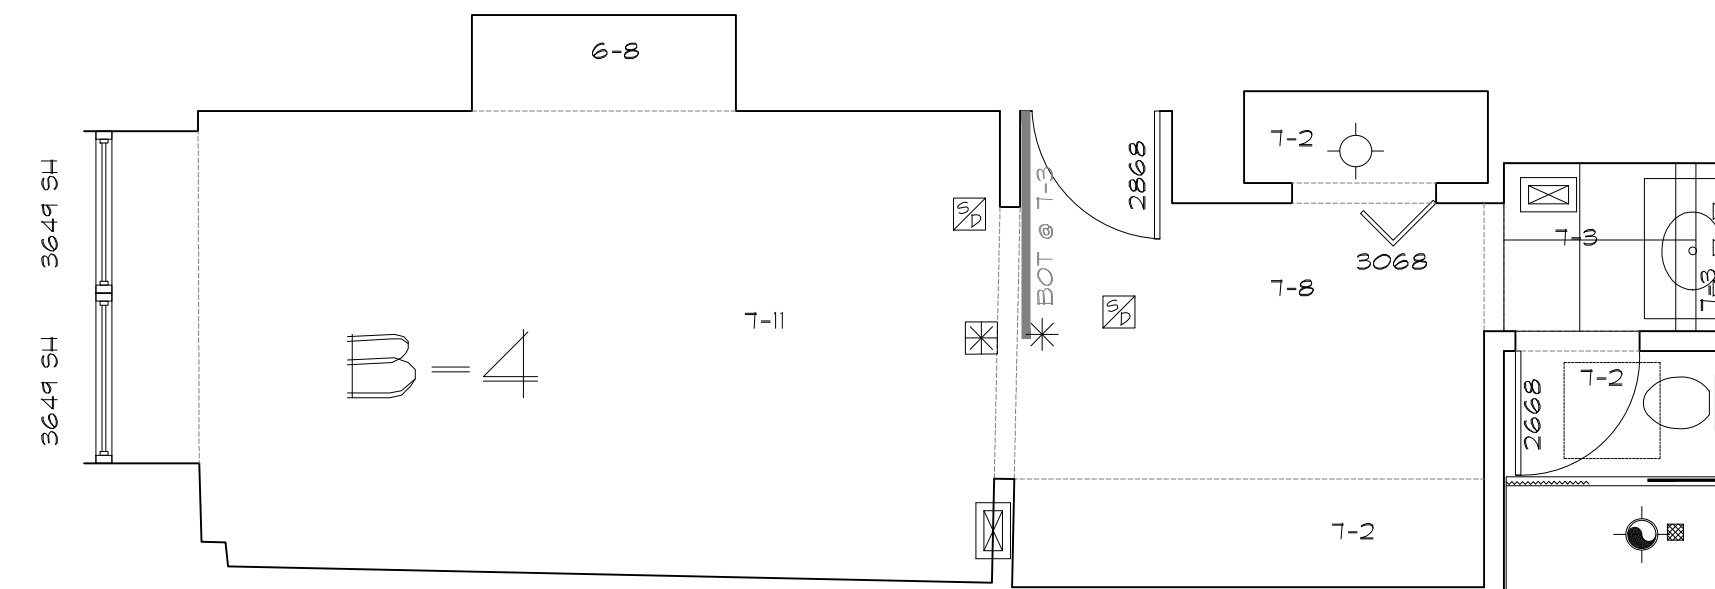

B-4
X15


B-4 - QTY: 11 (315-1415)

ROOM LAYOUTS 1/4"=1'-0"


ARCHITECTURAL AS BUILT HOTEL INDIGO

1244 N DEARBORN STREET CHICAGO, IL 60610


01	100% SUBMISSION	
NO.	ISSUES REVISIONS	DATE
		SHEET TITLE
HL	PROJECT MANAGER	
HL	PROJECT DIRECTOR	
9-2-16-1	PROJECT NUMBER	
AS NOTED	SCALE	
CL	DRAWN BY	
		SHEET NUMBER
ABR-3		

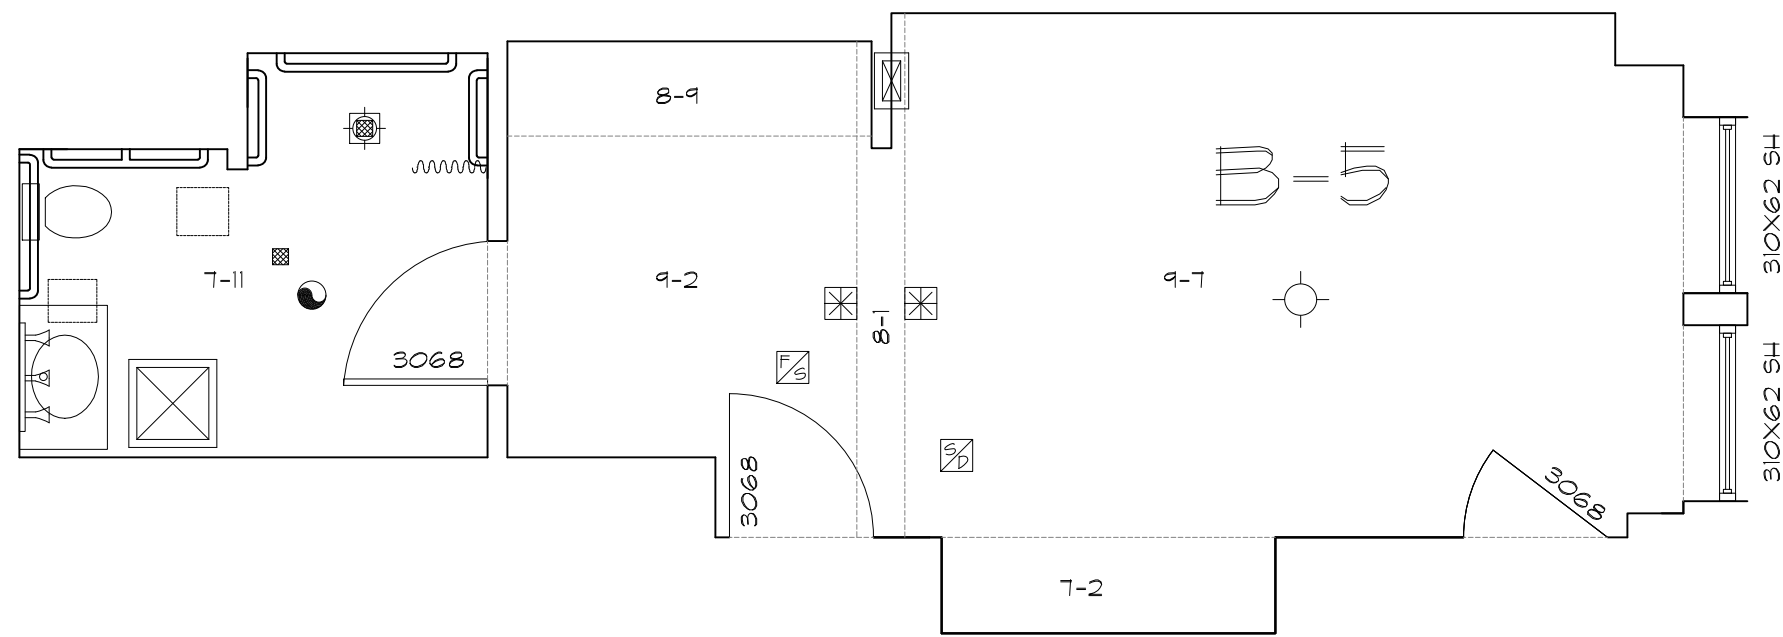


B-5
X01
B-5 ADA - QTY: 1 (201)

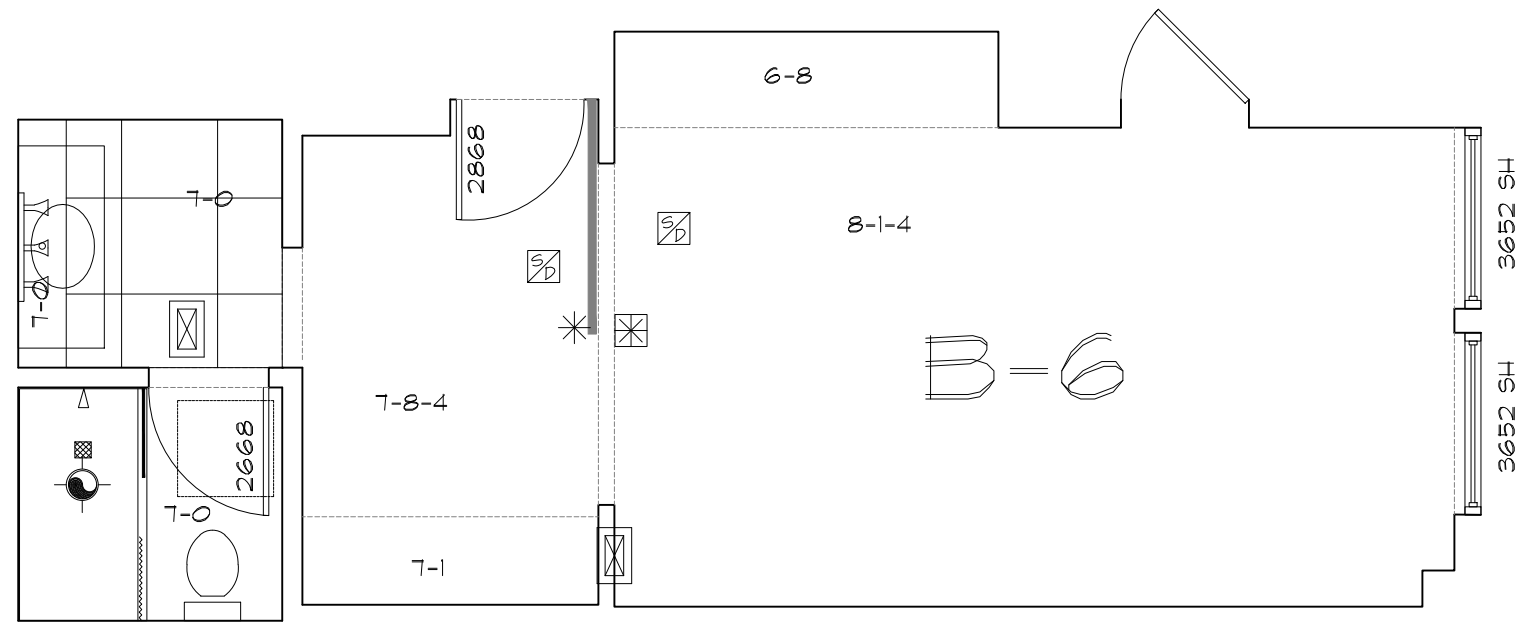


B-6
X03
B-6 - QTY: 2 (1203 & 1403)

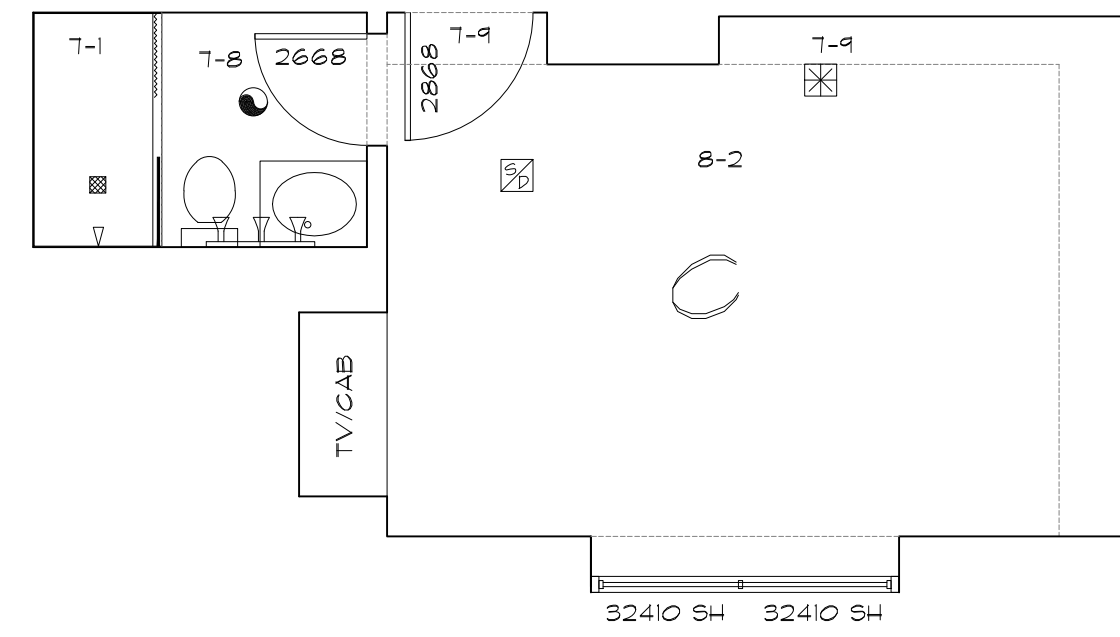


C
X06
C - QTY: 11 (306-1406)

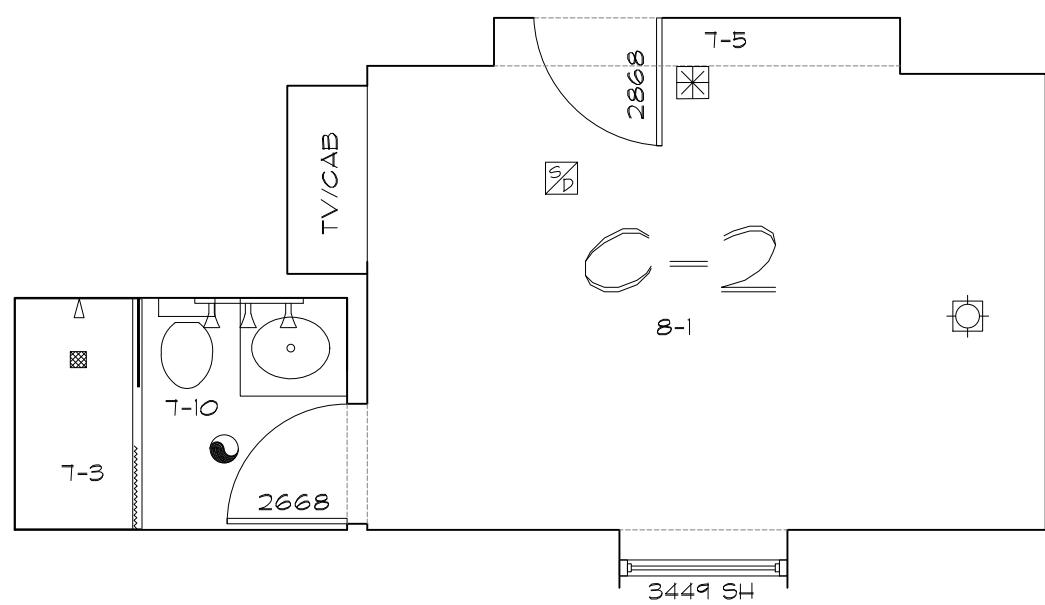

C-2
X10
C-2 - QTY: 11 (310-1410)

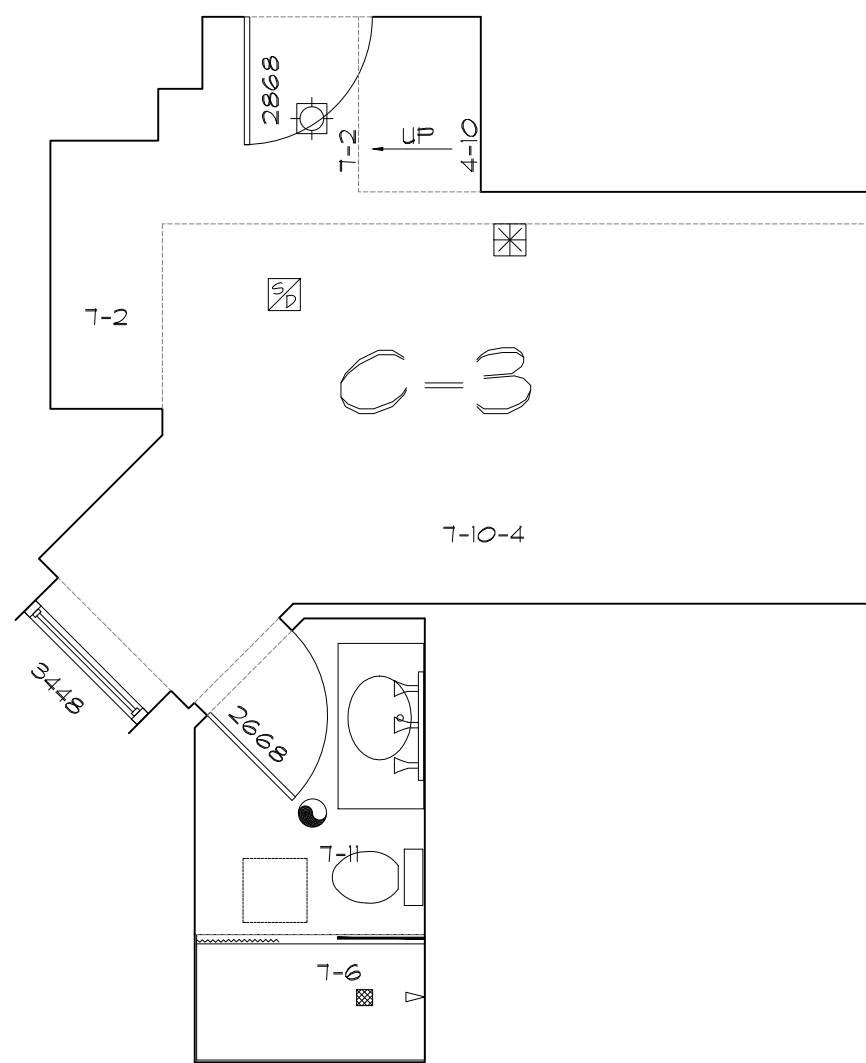

C-3
X04
C-3 - QTY: 1 (1404)

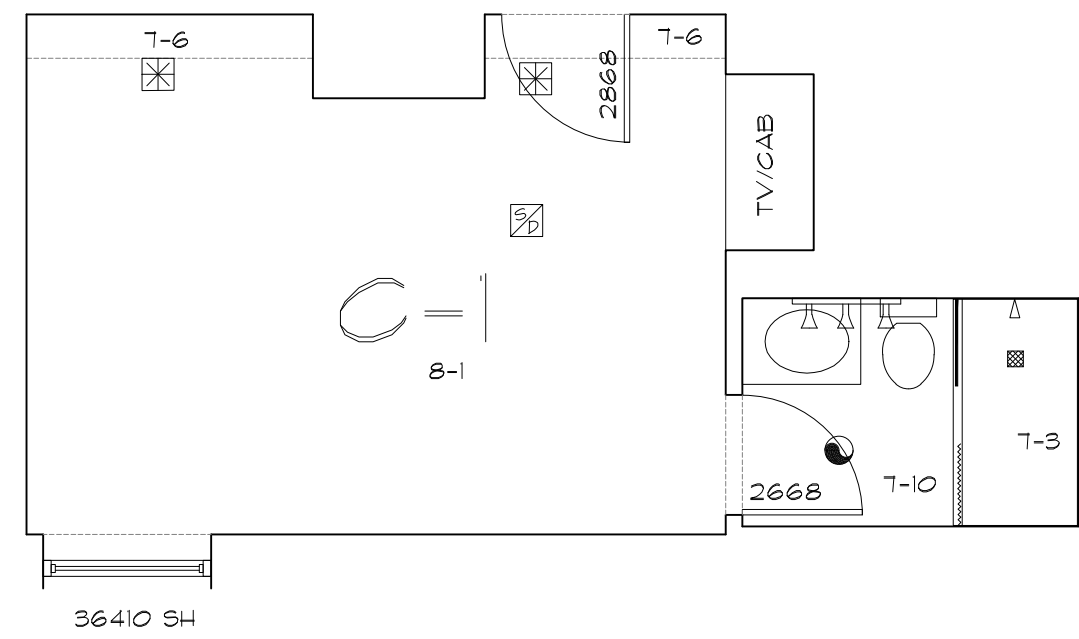


C-1
X08
C-1 - QTY: 11 (308-1408)

ROOM LAYOUTS 1/4"=1'-0"

ARCHITECTURAL AS BUILT
HOTEL INDIGO
1244 N DEARBORN STREET CHICAGO, IL 60610

01	100% SUBMISSION	
NO.	ISSUES REVISIONS	DATE
SHEET TITLE		
HL	PROJECT MANAGER	
HL	PROJECT DIRECTOR	
9-2-16-1	PROJECT NUMBER	
AS NOTED	SCALE	
CL	DRAWN BY	
SHEET NUMBER		

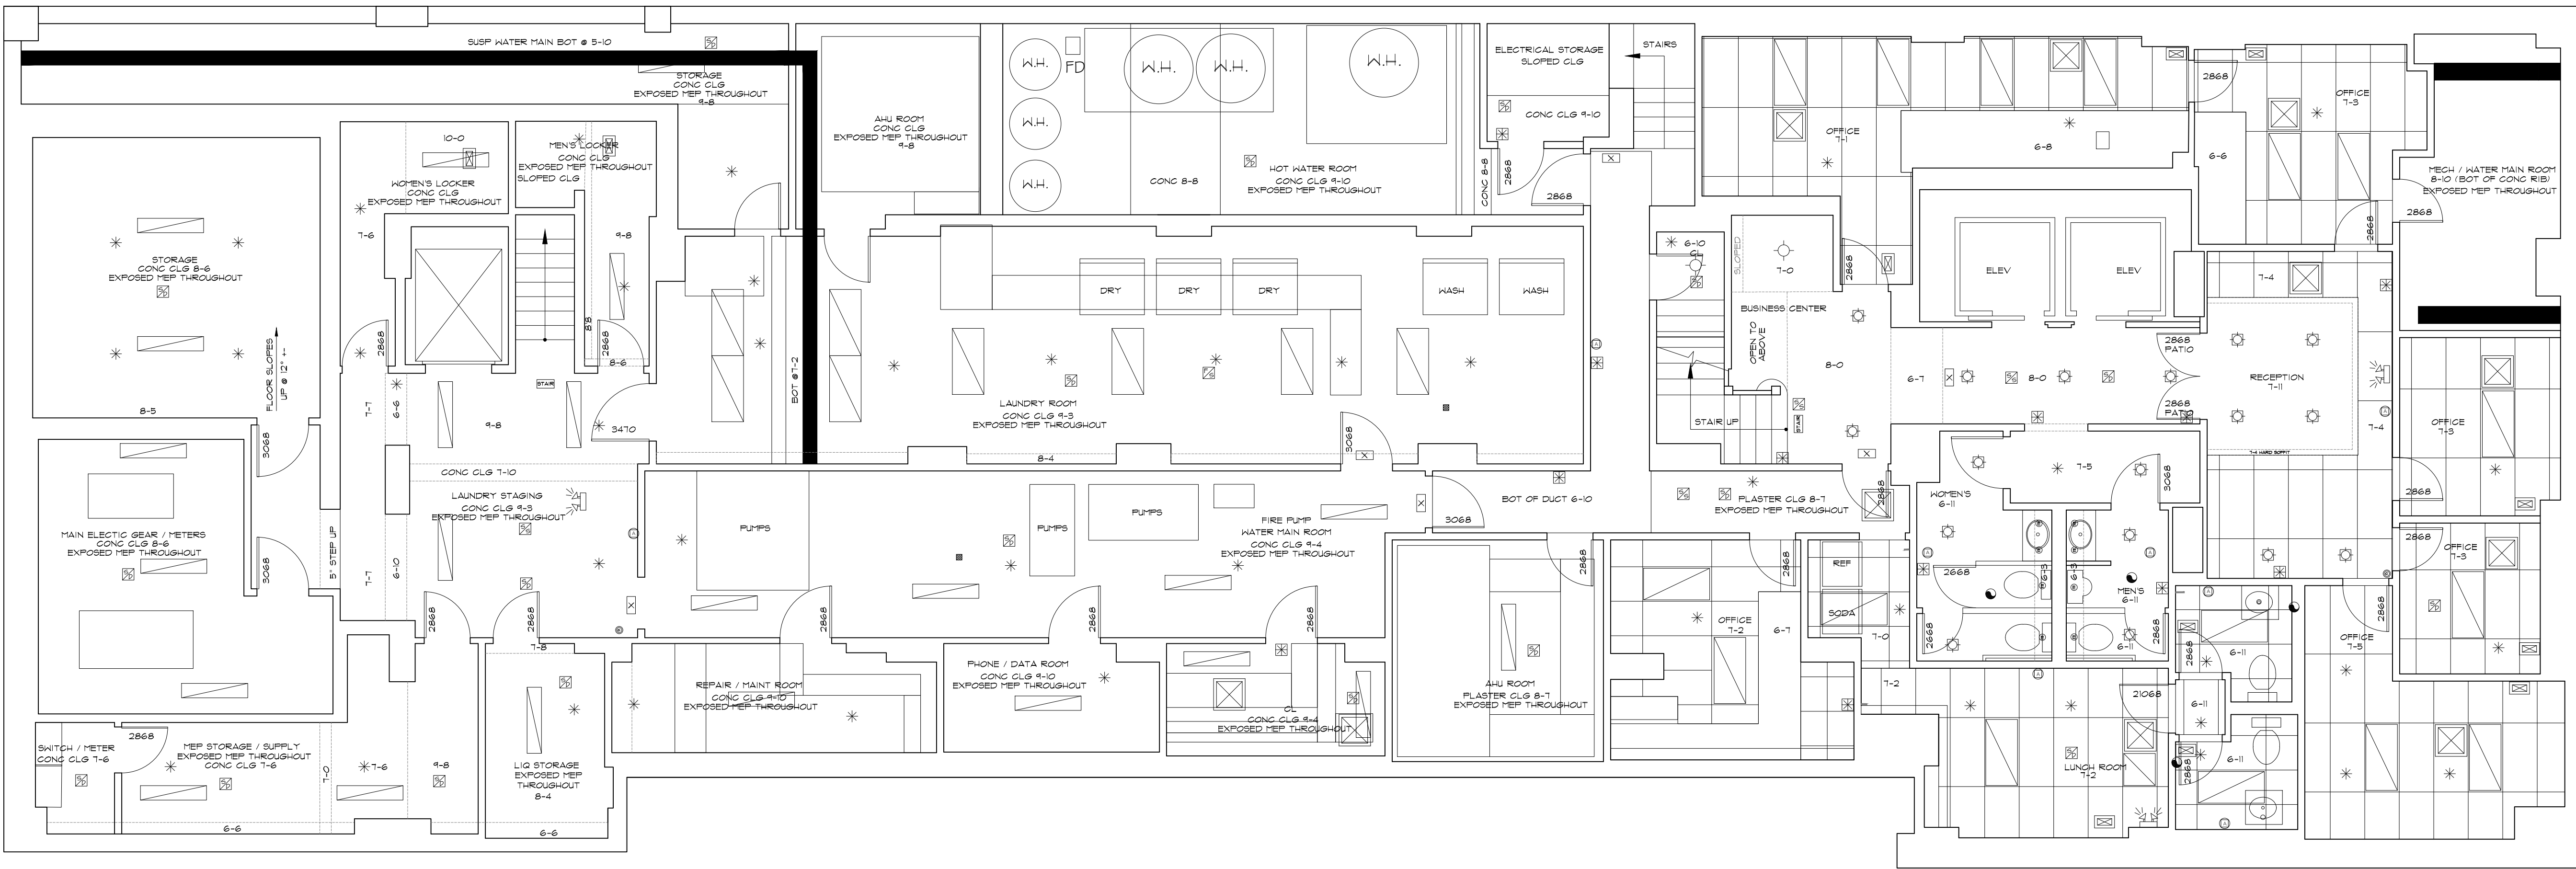

BASEMENT PLAN
3/16"=1'-0"

SYMBOLS LEGEND

RCP

- EXHAUST VENT
- CEILING MOUNTED LIGHT FIXTURE
- CEILING MOUNTED DIRECTIONAL LIGHT
- RECESSED CAN LIGHT
- EYEBALL OR SMALL CAN LIGHT
- PENDANT LIGHT
- INDIVIDUAL FLUOR. LAY-IN FIXTURE 4 BULB
- INDIVIDUAL FLUOR. HANGING FIXTURE 2 BULB
- INDIVIDUAL FLUOR. FLUSH MOUNT FIXTURE 4 BULB
- CAMERA
- MOTION DET.
- SUPPLY VENT
- SUPPLY VENT
- RETURN VENT
- RETURN VENT
- SPEAKER

- TRACK LIGHT OR VANITY LIGHT
- WALL-MOUNTED LIGHT FIXTURE
- EMERGENCY EXIT SIGN
- EMERGENCY EXIT LIGHT
- EMERGENCY EXIT LIGHT W/ SIGN
- LIGHTED STAIR SIGN
- FLOOD LIGHT
- PHOTO CELL
- CEILING FAN
- CEILING FAN W/ LIGHT KIT
- 7-2-6 CEILING HEIGHT AND TRIM 7'-2" ABOVE FLOOR BELOW WITH 6" CROWN MOULDING. NOTE: ALL CEILINGS NOT LABELED ARE PLASTER CEILINGS SHOWN WITH A GRID ARE LAY IN ACOUSTICAL TILE..
- JUNCTION BOX

ELECTRIC

- DATA OUTLET
- TELEPHONE JACK
- ELECTRIC SWITCH
- CABLE TELEVISION OUTLET
- DUPLEX RECEPTACLE OUTLET
- SPECIAL PURPOSE CONNECTION OR OUTLET
- QUADRUPEX RECEPTACLE OUTLET
- FLOOR DUPLEX RECEPTACLE OUTLET
- ELECTRIC PANEL
- ELECTRIC METER
- BUTTON SWITCH
- DISCONNECT SWITCH
- GROUND/FLOOR LIGHT
- KEY PAD

FIRE PROTECTION

- FIRE EXTINGUISHER
- FIRE PULL
- FIRE ALARM (HORN/STROBE)
- SMOKE DETECTOR
- SMOKE ALARM SPEAKER
- SPRINKLER HEAD CEILING MOUNT
- SPRINKLER HEAD WALL MOUNT

MEP

- THERMOSTAT
- FLOOR DRAIN
- VALVE
- HOSE BIB
- WATER SUPPLY
- SUSPENDED GAS HEATER

MISC

- BOLLARD


ARCHITECTURAL AS BUILT HOTEL INDIGO 1244 N DEARBORN STREET CHICAGO, IL 60610

01	100% SUBMISSION
NO.	ISSUES REVISIONS

SHEET TITLE

HL	PROJECT MANAGER
HL	PROJECT DIRECTOR
9-2-16-1	PROJECT NUMBER
AS NOTED	SCALE
CL	DRAWN BY
	SHEET NUMBER

AB-1

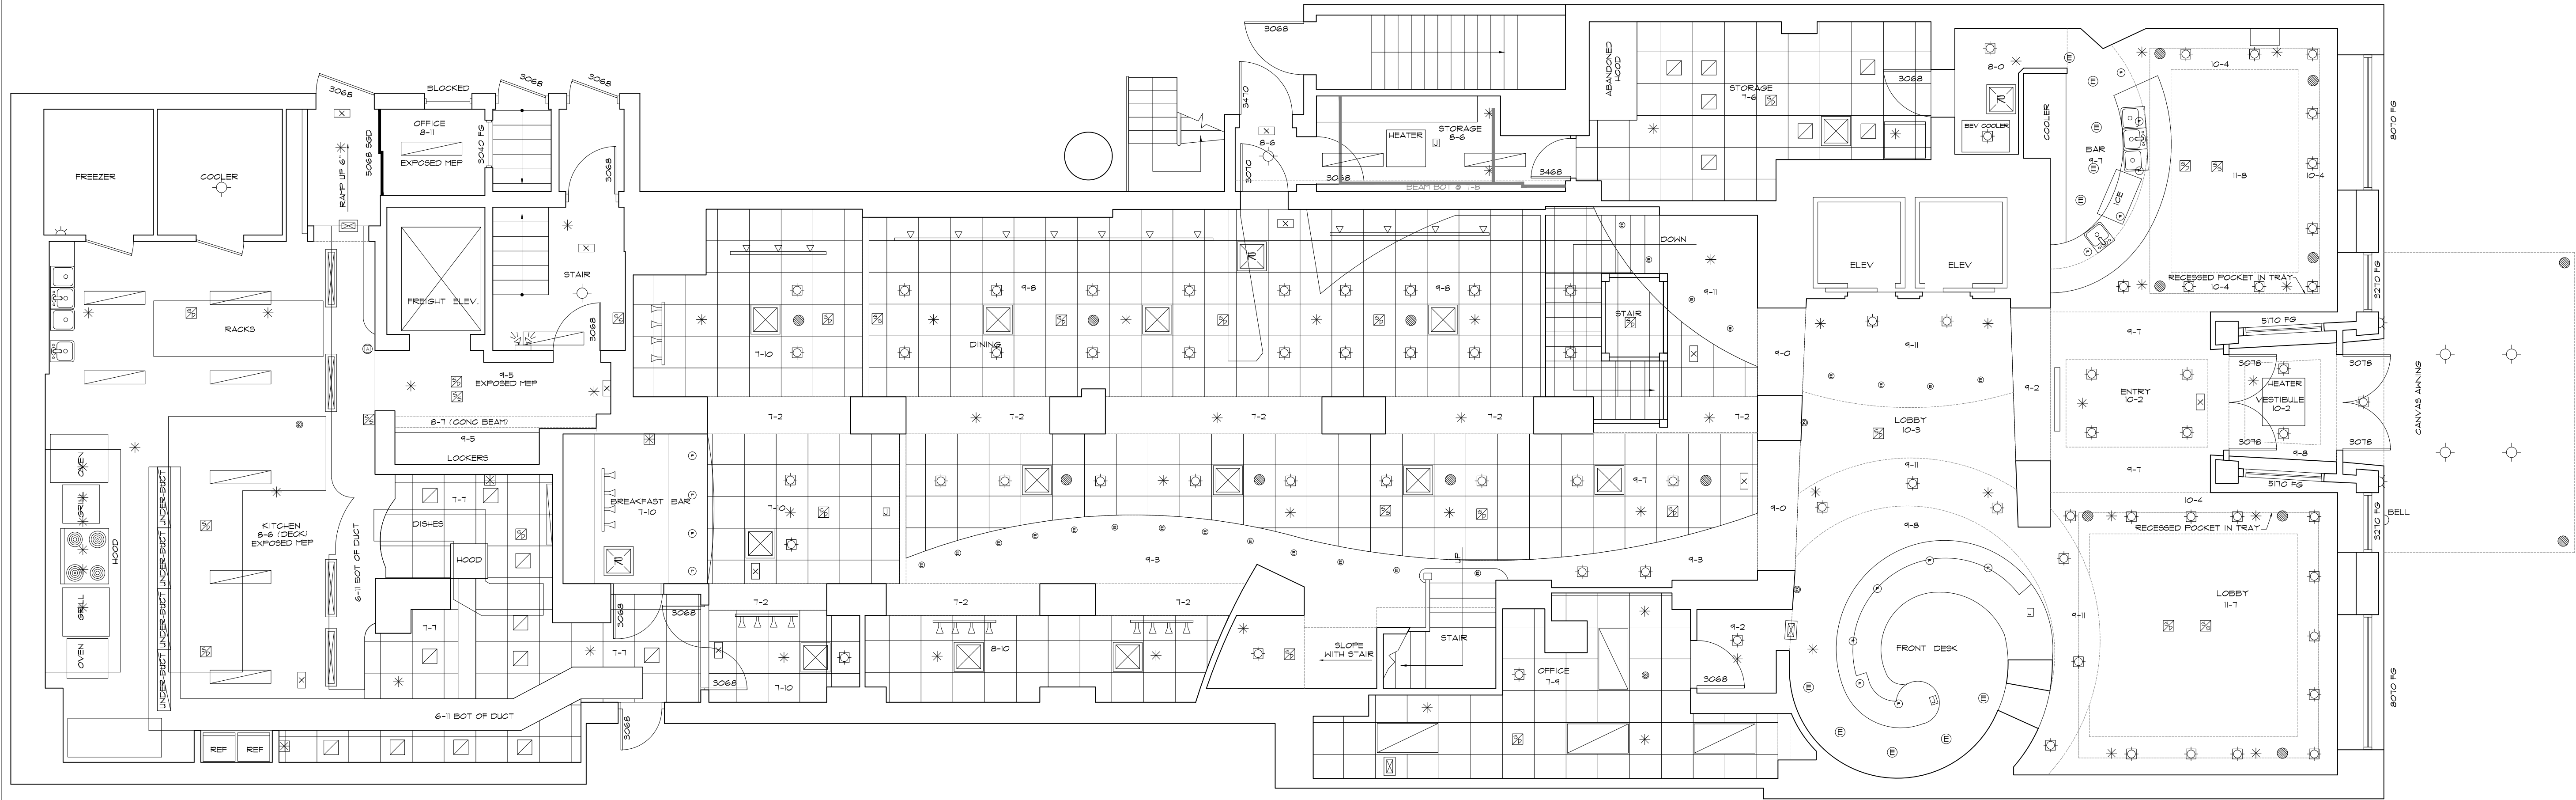

1 GROUND FLOOR PLAN
3/16"=1'-0"

SYMBOLS LEGEND

RCP

	EXHAUST VENT		TRACK LIGHT OR VANITY LIGHT
	CEILING MOUNTED LIGHT FIXTURE		WALL-MOUNTED LIGHT FIXTURE
	CEILING MOUNTED DIRECTIONAL LIGHT		EMERGENCY EXIT SIGN
	RECESSED CAN LIGHT		EMERGENCY EXIT LIGHT
	EYEBALL OR SMALL CAN LIGHT		EMERGENCY EXIT LIGHT W/ SIGN
	PENDANT LIGHT		LIGHTED STAIR SIGN
	INDIVIDUAL FLUOR. LAY-IN FIXTURE 4 BULB		FLOOD LIGHT
	INDIVIDUAL FLUOR. HANGING FIXTURE 2 BULB		PHOTO CELL
	INDIVIDUAL FLUOR. FLUSH MOUNT FIXTURE 4 BULB		CEILING FAN
	CAMERA		CEILING FAN W/ LIGHT KIT
	MOTION DET.		7'-2"-6" CEILING HEIGHT AND TRIM 7'-2" ABOVE FLOOR BELOW WITH 6" CROWN MOULDING. NOTE: ALL CEILINGS NOT LABELED ARE PLASTER. CEILINGS SHOWN WITH A GRID ARE LAY IN ACOUSTICAL TILE..
	SUPPLY VENT		JUNCTION BOX
	SUPPLY VENT		
	RETURN VENT		
	RETURN VENT		
	SPEAKER		

ELECTRIC

	DATA OUTLET
	TELEPHONE JACK
	ELECTRIC SWITCH
	CABLE TELEVISION OUTLET
	DUPLEX RECEPTACLE OUTLET
	SPECIAL PURPOSE CONNECTION OR OUTLET
	QUADRUPEX RECEPTACLE OUTLET
	FLOOR DUPLEX RECEPTACLE OUTLET
	ELECTRIC PANEL
	ELECTRIC METER
	BUTTON SWITCH
	DISCONNECT SWITCH
	GROUND/FLOOR LIGHT
	KEY PAD

FIRE PROTECTION

	FIRE EXTINGUISHER
	FIRE PULL
	FIRE ALARM (HORN/SRTOKE)
	SMOKE DETECTOR
	SMOKE ALARM SPEAKER
	SPRINKLER HEAD CEILING MOUNT
	SPRINKLER HEAD WALL MOUNT

MEP

	THERMOSTAT
	FLOOR DRAIN
	VALVE
	HOSE BIB
	WATER SUPPLY
	SUSPENDED GAS HEATER

MISC

	BOLLARD
--	---------

AS BUILT
PROFESSIONALS
A DIVISION OF:


AEC
CONSULTANTS INC
www.aecconsultantsinc.com
844.272.8458

© 2016 AEC CONSULTANTS INC

ARCHITECTURAL AS BUILT
HOTEL INDIGO
1244 N DEARBORN STREET CHICAGO, IL 60610

01	100% SUBMISSION	
NO.	ISSUES REVISIONS	DATE
SHEET TITLE		
HL	PROJECT MANAGER	
HL	PROJECT DIRECTOR	
9-2-16-1	PROJECT NUMBER	
AS NOTED	SCALE	
CL	DRAWN BY	
SHEET NUMBER		

AB-2

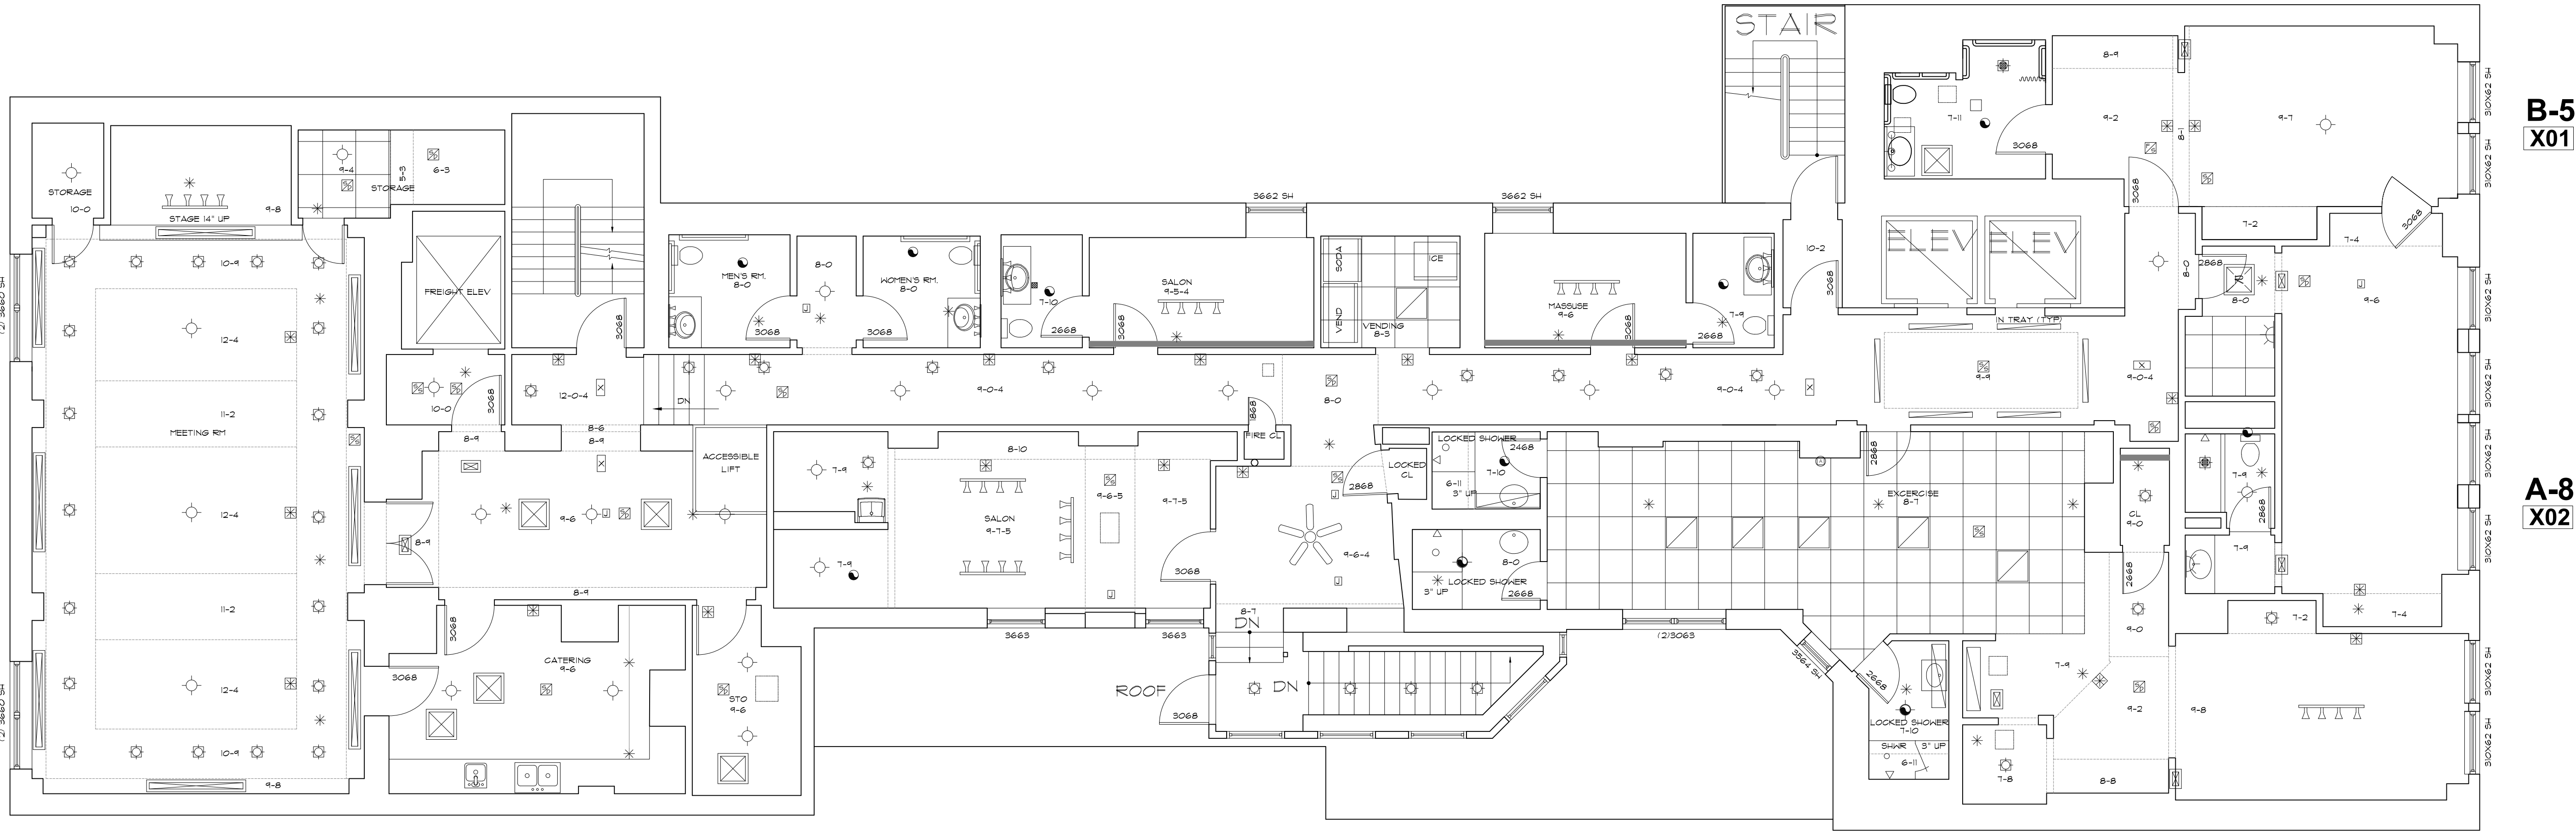

FLOOR 2
3/16"=1'-0"

B-5
X01

A-8
X02

AS BUILT
PROFESSIONALS
A DIVISION OF:

AEC
CONSULTANTS INC
www.aecconsultantsinc.com
844.272.8458

© 2016 AEC CONSULTANTS INC

ARCHITECTURAL AS BUILT
HOTEL INDIGO
1244 N DEARBORN STREET CHICAGO, IL 60610

SYMBOLS LEGEND

RCP

- EXHAUST VENT
- CEILING MOUNTED LIGHT FIXTURE
- CEILING MOUNTED DIRECTIONAL LIGHT
- RECESSED CAN LIGHT
- EYEBALL OR SMALL CAN LIGHT
- PENDANT LIGHT
- INDIVIDUAL FLUOR. LAY-IN FIXTURE 4 BULB
- INDIVIDUAL FLUOR. HANGING FIXTURE 2 BULB
- INDIVIDUAL FLUOR. FLUSH MOUNT FIXTURE 4 BULB
- CAMERA
- MOTION DET.
- SUPPLY VENT
- SUPPLY VENT
- RETURN VENT
- RETURN VENT
- SPEAKER

- TRACK LIGHT OR VANITY LIGHT
- WALL-MOUNTED LIGHT FIXTURE
- EMERGENCY EXIT SIGN
- EMERGENCY EXIT LIGHT
- EMERGENCY EXIT LIGHT W/ SIGN
- LIGHTED STAIR SIGN
- FLOOD LIGHT
- PHOTO CELL
- CEILING FAN
- CEILING FAN W/ LIGHT KIT
- 7-2-6 CEILING HEIGHT AND TRIM 7'-2" ABOVE FLOOR BELOW WITH 6" CROWN MOULDING. NOTE: ALL CEILINGS NOT LABELED ARE PLASTER CEILINGS SHOWN WITH A GRID ARE LAY IN ACOUSTICAL TILE..
- JUNCTION BOX

ELECTRIC

- DATA OUTLET
- TELEPHONE JACK
- ELECTRIC SWITCH
- CABLE TELEVISION OUTLET
- DUPLEX RECEPTACLE OUTLET
- SPECIAL PURPOSE CONNECTION OR OUTLET
- QUADRUPEX RECEPTACLE OUTLET
- FLOOR DUPLEX RECEPTACLE OUTLET
- ELECTRIC PANEL
- ELECTRIC METER
- BUTTON SWITCH
- DISCONNECT SWITCH
- GROUND/FLOOR LIGHT
- KEY PAD

FIRE PROTECTION

- FIRE EXTINGUISHER
- FIRE PULL
- FIRE ALARM (HORN/SRTOBE)
- SMOKE DETECTOR
- SMOKE ALARM SPEAKER
- SPRINKLER HEAD CEILING MOUNT
- SPRINKLER HEAD WALL MOUNT

MEP


- THERMOSTAT
- FLOOR DRAIN
- VALVE
- HOSE BIB
- WATER SUPPLY
- SUSPENDED GAS HEATER

MISC

- BOLLARD

01	100% SUBMISSION	
NO.	ISSUES REVISIONS	DATE
SHEET TITLE		
HL	PROJECT MANAGER	
HL	PROJECT DIRECTOR	
9-2-16-1	PROJECT NUMBER	
AS NOTED	SCALE	
CL	DRAWN BY	
SHEET NUMBER		









AB-3

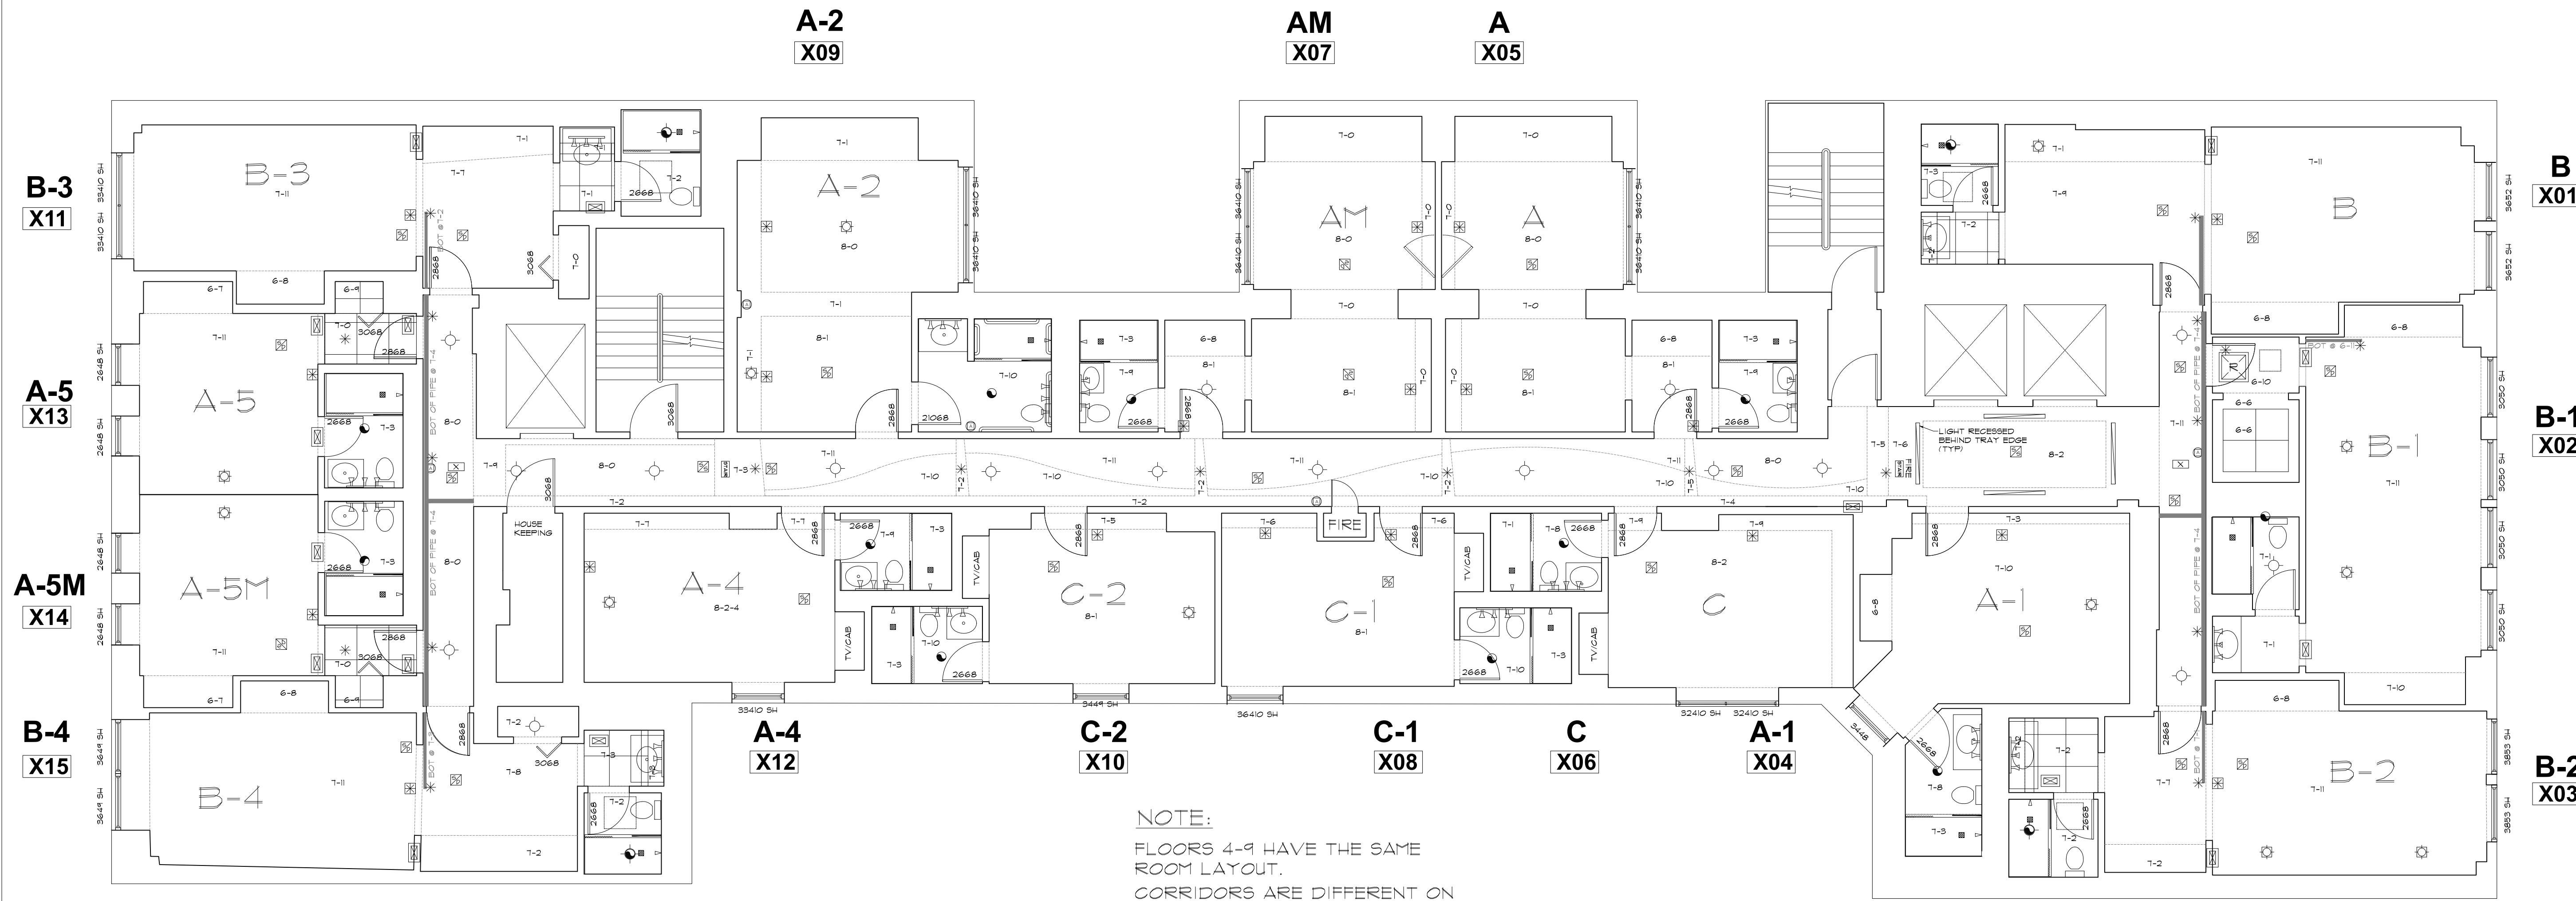

NOTE:
FLOORS 4-9 HAVE THE SAME
ROOM LAYOUT.
CORRIDORS ARE DIFFERENT ON
EVERY FLOOR.

FLOOR 4
3/16" = 1'-0"

        SYMBOLS LEGEND

RCP		ELECTRIC		FIRE PROTECTION	
	EXHAUST VENT		TRACK LIGHT OR VANITY LIGHT		FIRE EXTINGUISHER
	CEILING MOUNTED LIGHT FIXTURE		WALL-MOUNTED LIGHT FIXTURE		FIRE PULL
	CEILING MOUNTED DIRECTIONAL LIGHT		EMERGENCY EXIT SIGN		FIRE ALARM (HORN/SRTO BE)
	RECESSED CAN LIGHT		EMERGENCY EXIT LIGHT		SMOKE DETECTOR
	EYEBALL OR SMALL CAN LIGHT		EMERGENCY EXIT LIGHT W/ SIGN		SMOKE ALARM SPEAKER
	PENDANT LIGHT		LIGHTED STAIR SIGN		SPRINKLER HEAD CEILING MOUNT
	INDIVIDUAL FLUOR. LAY-IN FIXTURE 4 BULB		FLOOD LIGHT		SPRINKLER HEAD WALL MOUNT
	INDIVIDUAL FLUOR. HANGING FIXTURE 2 BULB		PHOTO CELL	MEP	
	INDIVIDUAL FLUOR. FLUSH MOUNT FIXTURE 4 BULB		CEILING FAN		
	CAMERA		CEILING FAN W/ LIGHT KIT		
	MOTION DET.		CEILING HEIGHT AND TRIM 7'-2" ABOVE FLOOR BELOW WITH 6" CROWN MOULDING. NOTE: ALL CEILINGS NOT LABELED ARE PLASTER CEILINGS SHOWN WITH A GRID ARE LAY IN ACOUSTICAL TILE..		
	SUPPLY VENT		JUNCTION BOX	MISC	
	SUPPLY VENT				
	RETURN VENT				
	RETURN VENT				
	SPEAKER				BOLLARD

As BUILT

PROFESSIONALS

A DIVISION OF:

AEC

CONSULTANTS INC

www.aecconsultantsinc.com

844.272.8458


© 2016 AEC CONSULTANTS INC

ARCHITECTURAL AS BUILT

HOTEL INDIGO

1244 N DEARBORN STREET CHICAGO, IL 60610

01	100% SUBMISSION	
NO.	ISSUES REVISIONS	DATE
		SHEET TITLE

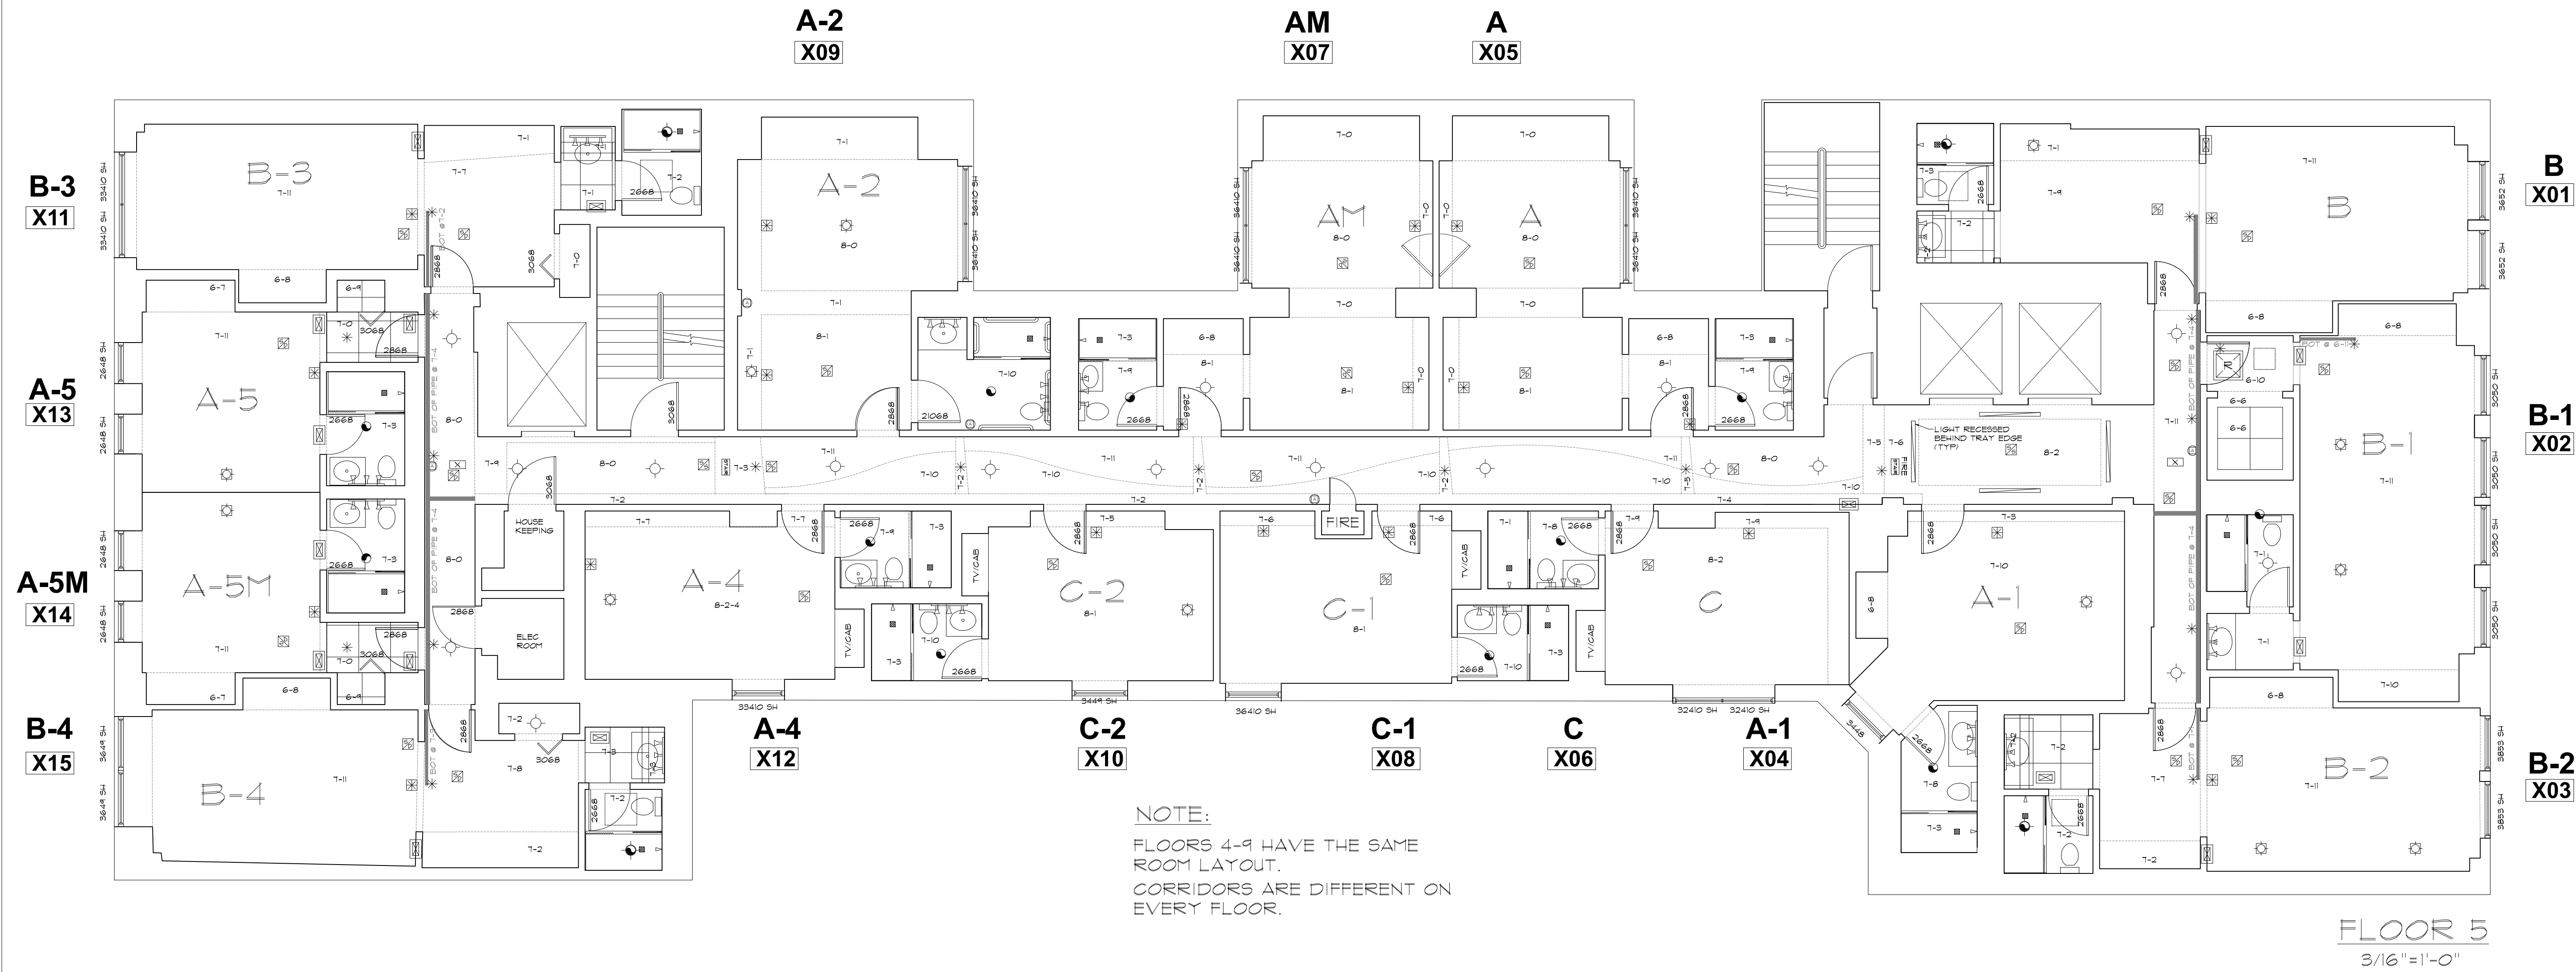

SYMBOLS LEGEND

RCP			ELECTRIC		FIRE PROTECTION	
	EXHAUST VENT			DATA OUTLET		FIRE EXTINGUISHER
	CEILING MOUNTED LIGHT FIXTURE			TELEPHONE JACK		FIRE PULL
	CEILING MOUNTED DIRECTIONAL LIGHT			ELECTRIC SWITCH		FIRE ALARM (HORN/STROBE)
	RECESSED CAN LIGHT			CABLE TELEVISION OUTLET		SMOKE DETECTOR
	EYEBALL OR SMALL CAN LIGHT			DUPLEX RECEPTACLE OUTLET		SMOKE ALARM SPEAKER
	PENDANT LIGHT			SPECIAL PURPOSE CONNECTION OR OUTLET		SPRINKLER HEAD CEILING MOUNT
	INDIVIDUAL FLUOR. LAY-IN FIXTURE 4 BULB			QUADRUPEX RECEPTACLE OUTLET		SPRINKLER HEAD WALL MOUNT
	INDIVIDUAL FLUOR. HANGING FIXTURE 2 BULB			FLOOR DUPLEX RECEPTACLE OUTLET	MEP THERMOSTAT FLOOR DRAIN VALVE HOSE BIB WATER SUPPLY SUSPENDED GAS HEATER	
	INDIVIDUAL FLUOR. FLUSH MOUNT FIXTURE 4 BULB			ELECTRIC PANEL		
	CAMERA			ELECTRIC METER		
	MOTION DET.			BUTTON SWITCH		
	SUPPLY VENT	7-2-6 CEILING HEIGHT AND TRIM 7'-2" ABOVE FLOOR BELOW WITH 6" CROWN MOULDING. NOTE: ALL CEILINGS NOT LABELED ARE PLASTER CEILINGS SHOWN WITH A GRID ARE LAY IN ACOUSTICAL TILE..		DISCONNECT SWITCH	MISC BOLLARD	
	RETURN VENT			GROUND/FLOOR LIGHT		
	RETURN VENT			KEY PAD		
	SPEAKER					

As BUILT
PROFESSIONALS
A DIVISION OF:

AEC

CONSULTANTS INC


www.aecconsultantsinc.com

844.272.8458

© 2016 AEC CONSULTANTS INC

ARCHITECTURAL AS BUILT
HOTEL INDIGO
1244 N DEARBORN STREET CHICAGO, IL 60610

01	100% SUBMISSION	
NO.	ISSUES REVISIONS	DATE
		SHEET TITLE
HL	PROJECT MANAGER	
HL	PROJECT DIRECTOR	
9-2-16-1	PROJECT NUMBER	
AS NOTED	SCALE	
CL	DRAWN BY	
		SHEET NUMBER
AB-6		

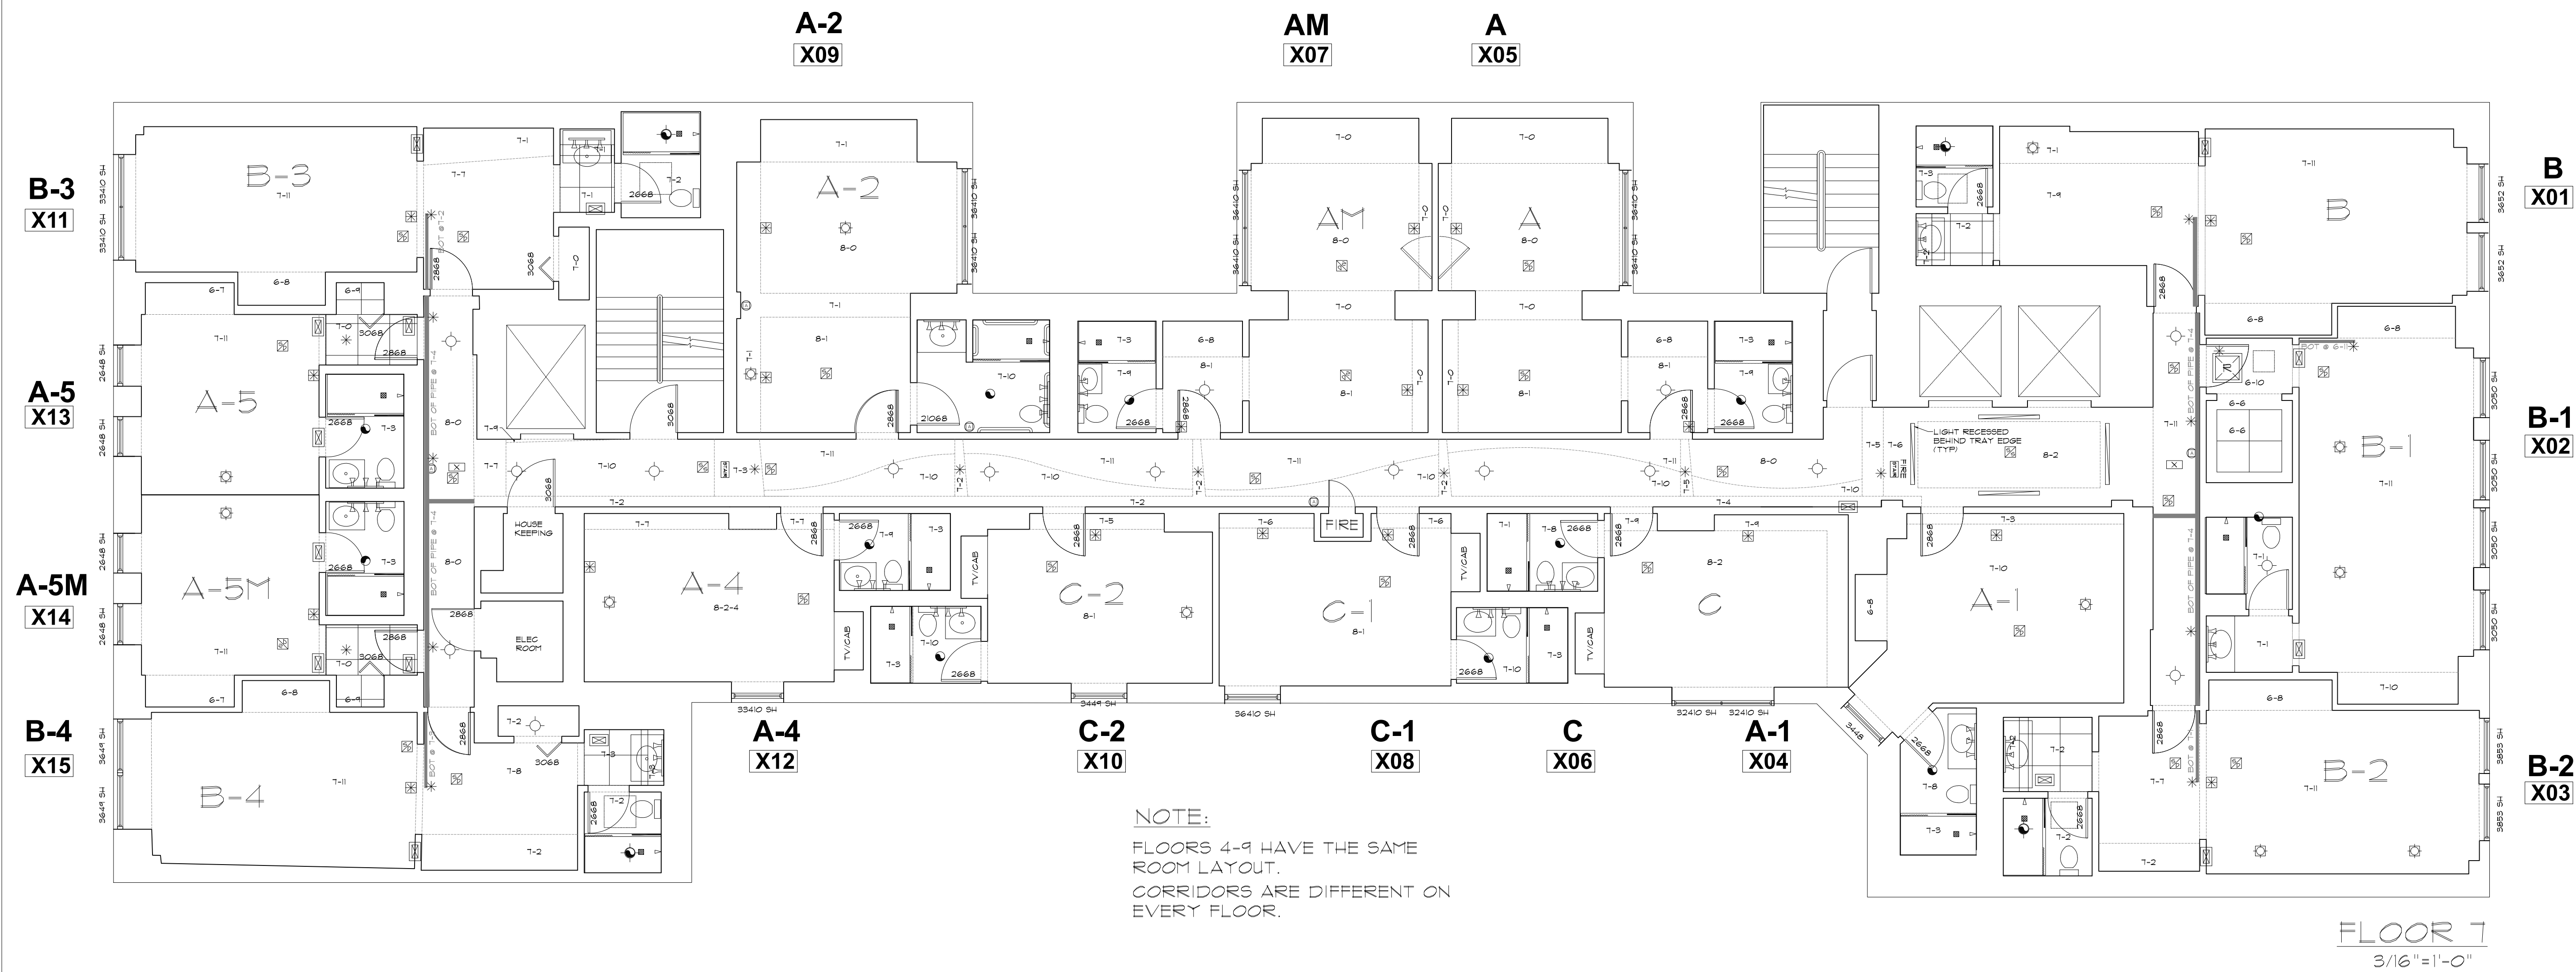

SYMBOLS LEGEND

RCP			ELECTRIC		FIRE PROTECTION	
	EXHAUST VENT			DATA OUTLET		FIRE EXTINGUISHER
	CEILING MOUNTED LIGHT FIXTURE			TELEPHONE JACK		FIRE PULL
	CEILING MOUNTED DIRECTIONAL LIGHT			ELECTRIC SWITCH		FIRE ALARM (HORN/SRTOKE)
	RECESSED CAN LIGHT			CABLE TELEVISION OUTLET		SMOKE DETECTOR
	EYEBALL OR SMALL CAN LIGHT			DUPLEX RECEPTACLE OUTLET		SMOKE ALARM SPEAKER
	PENDANT LIGHT			SPECIAL PURPOSE CONNECTION OR OUTLET		SPRINKLER HEAD CEILING MOUNT
	INDIVIDUAL FLUOR. LAY-IN FIXTURE 4 BULB			QUADRUPEX RECEPTACLE OUTLET		SPRINKLER HEAD WALL MOUNT
	INDIVIDUAL FLUOR. HANGING FIXTURE 2 BULB			FLOOR DUPLEX RECEPTACLE OUTLET	MEP THERMOSTAT FLOOR DRAIN VALVE HOSE BIB WATER SUPPLY SUSPENDED GAS HEATER	
	INDIVIDUAL FLUOR. FLUSH MOUNT FIXTURE 4 BULB			ELECTRIC PANEL		
	CAMERA			ELECTRIC METER		
	MOTION DET.			BUTTON SWITCH		
	SUPPLY VENT			DISCONNECT SWITCH	MISC BOLLARD	
	RETURN VENT			GROUND/FLOOR LIGHT		
	RETURN VENT			KEY PAD		
	SPEAKER					

AS BUILT
PROFESSIONALS

A DIVISION OF:

AEC
CONSULTANTS INC

www.aecconsultantsinc.com

844.272.8458

© 2016 AEC CONSULTANTS INC

ARCHITECTURAL AS BUILT


HOTEL INDIGO

1244 N DEARBORN STREET CHICAGO, IL 60610

01	100% SUBMISSION	
NO.	ISSUES REVISIONS	DATE
		SHEET TITLE
HL	PROJECT MANAGER	
HL	PROJECT DIRECTOR	
9-2-16-1	PROJECT NUMBER	
AS NOTED	SCALE	
CL	DRAWN BY	
		SHEET NUMBER
AB-8		




ARCHITECTURAL AS BUILT
HOTEL INDIGO
1244 N DEARBORN STREET CHICAGO, IL 60610

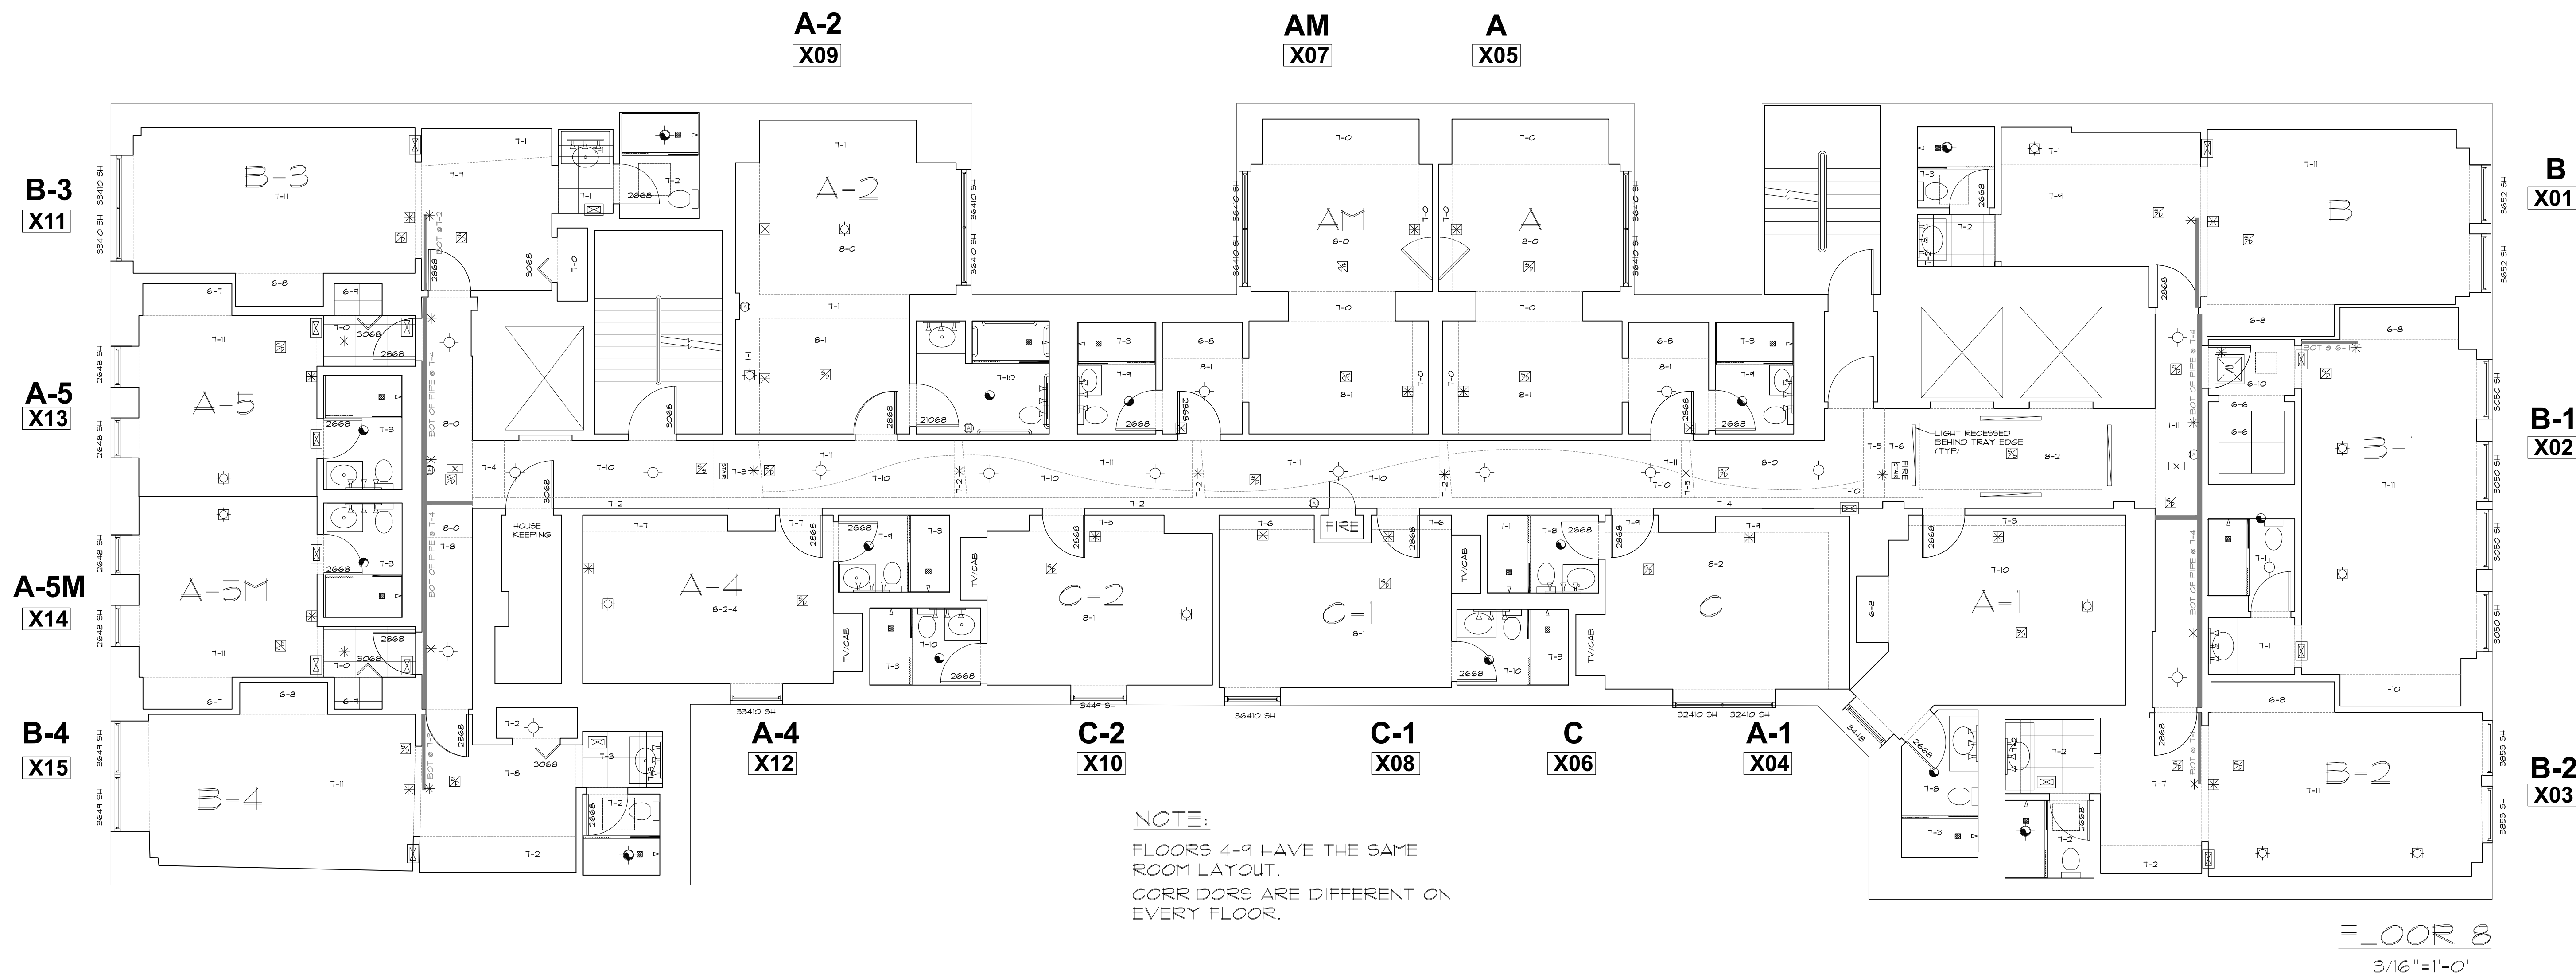

SYMBOLS LEGEND

RCP	ELECTRIC	FIRE PROTECTION
EXHAUST VENT CEILING MOUNTED LIGHT FIXTURE CEILING MOUNTED DIRECTIONAL LIGHT RECESSED CAN LIGHT EYEBALL OR SMALL CAN LIGHT PENDANT LIGHT INDIVIDUAL FLOOR LAMIN FIXTURE 4 BULB INDIVIDUAL FLOOR HANGING FIXTURE 2 BULB INDIVIDUAL FLOOR FLUSH MOUNT FIXTURE 4 BULB CAMERA MOTION DET. SUPPLY VENT RETURN VENT SPEAKER	TRACK LIGHT OR VANITY LIGHT WALL-MOUNTED LIGHT FIXTURE EMERGENCY EXIT SIGN EMERGENCY EXIT LIGHT EMERGENCY EXIT LIGHT W/ SIGN LIGHTED STAIR SIGN FLOOD LIGHT PHOTO CELL CEILING FAN 7-2-6 CEILING HEIGHT AND TRIM 7'-2" ABOVE FLOOR BELOW WITH 6" CROWN MOULDING. NOTE: ALL CEILINGS NOT LABELED ARE PLASTER JUNCTION BOX	DATA OUTLET TELEPHONE JACK ELECTRIC SWITCH CABLE TELEVISION OUTLET DUPLEX RECEPTACLE OUTLET SPECIAL PURPOSE CONNECTION OR OUTLET QUADRUPEX RECEPTACLE OUTLET FLOOR DUPLEX RECEPTACLE OUTLET ELECTRIC PANEL ELECTRIC METER BUTTON SWITCH DISCONNECT SWITCH GROUND/FLOOR LIGHT KEY PAD
		FIRE EXTINGUISHER FIRE PULL FIRE ALARM (HORN/SRTOBE) SMOKE DETECTOR SMOKE ALARM SPEAKER SPRINKLER HEAD CEILING MOUNT SPRINKLER HEAD WALL MOUNT
		MEP THERMOSTAT FLOOR DRAIN VALVE HOSE BIB WATER SUPPLY SUSPENDED GAS HEATER
		MISC BOLLARD

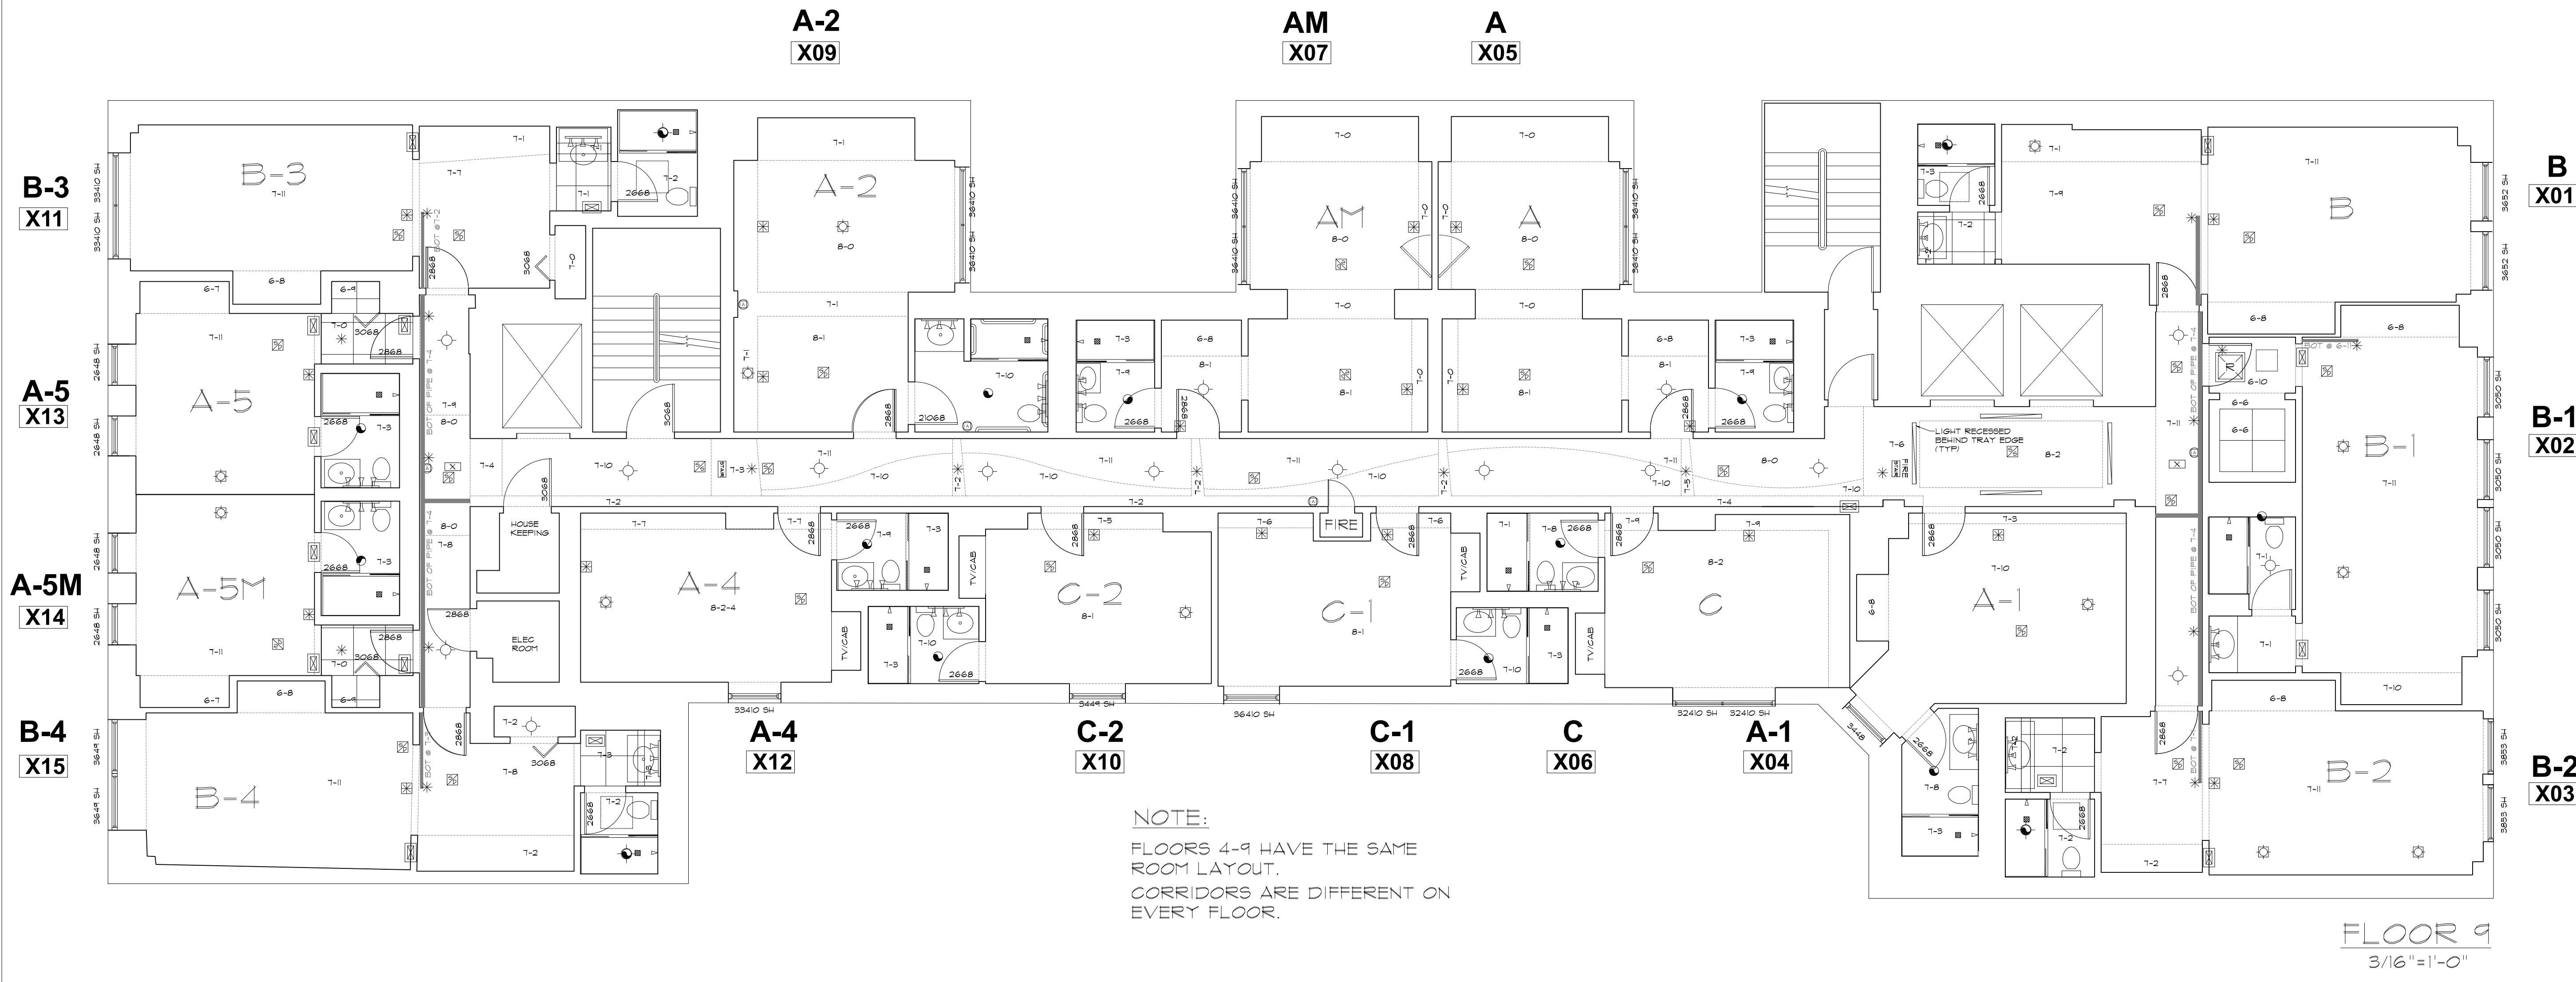

AS BUILT
PROFESSIONALS

A DIVISION OF:

AEC
CONSULTANTS INC

www.aecconsultantsinc.com

 
 
 
 
 
844.272.8458

© 2016 AEC CONSULTANTS INC


ARCHITECTURAL AS BUILT

HOTEL INDIGO

1244 N DEARBORN STREET CHICAGO, IL 60610

SYMBOLS LEGEND					
RCP		ELECTRIC		FIRE PROTECTION	
	EXHAUST VENT		TRACK LIGHT OR VANITY LIGHT		FIRE EXTINGUISHER
	CEILING MOUNTED LIGHT FIXTURE		WALL-MOUNTED LIGHT FIXTURE		FIRE PULL
	CEILING MOUNTED DIRECTIONAL LIGHT		EMERGENCY EXIT SIGN		FIRE ALARM (HORN/SRTOBE)
	RECESSED CAN LIGHT		EMERGENCY EXIT LIGHT		SMOKE DETECTOR
	EYEBALL OR SMALL CAN LIGHT		EMERGENCY EXIT LIGHT W/ SIGN		SMOKE ALARM SPEAKER
	PENDANT LIGHT		LIGHTED STAIR SIGN		SPRINKLER HEAD CEILING MOUNT
	INDIVIDUAL FLUOR. LAY-IN FIXTURE 4 BULB		FLOOD LIGHT		SPRINKLER HEAD WALL MOUNT
	INDIVIDUAL FLUOR. HANGING FIXTURE 2 BULB		PHOTO CELL		
	INDIVIDUAL FLUOR. FLUSH MOUNT FIXTURE 4 BULB		CEILING FAN		
	CAMERA		CEILING FAN W/ LIGHT KIT		
	MOTION DET.				
	SUPPLY VENT				
	SUPPLY VENT				
	RETURN VENT				
	RETURN VENT				
	SPEAKER				
			</		

01	100% SUBMISSION	
NO.	ISSUES REVISIONS	DATE
SHEET TITLE		
HL	PROJECT MANAGER	
HL	PROJECT DIRECTOR	
9-2-16-1	PROJECT NUMBER	
AS NOTED	SCALE	
CL	DRAWN BY	
SHEET NUMBER		
AB-10		

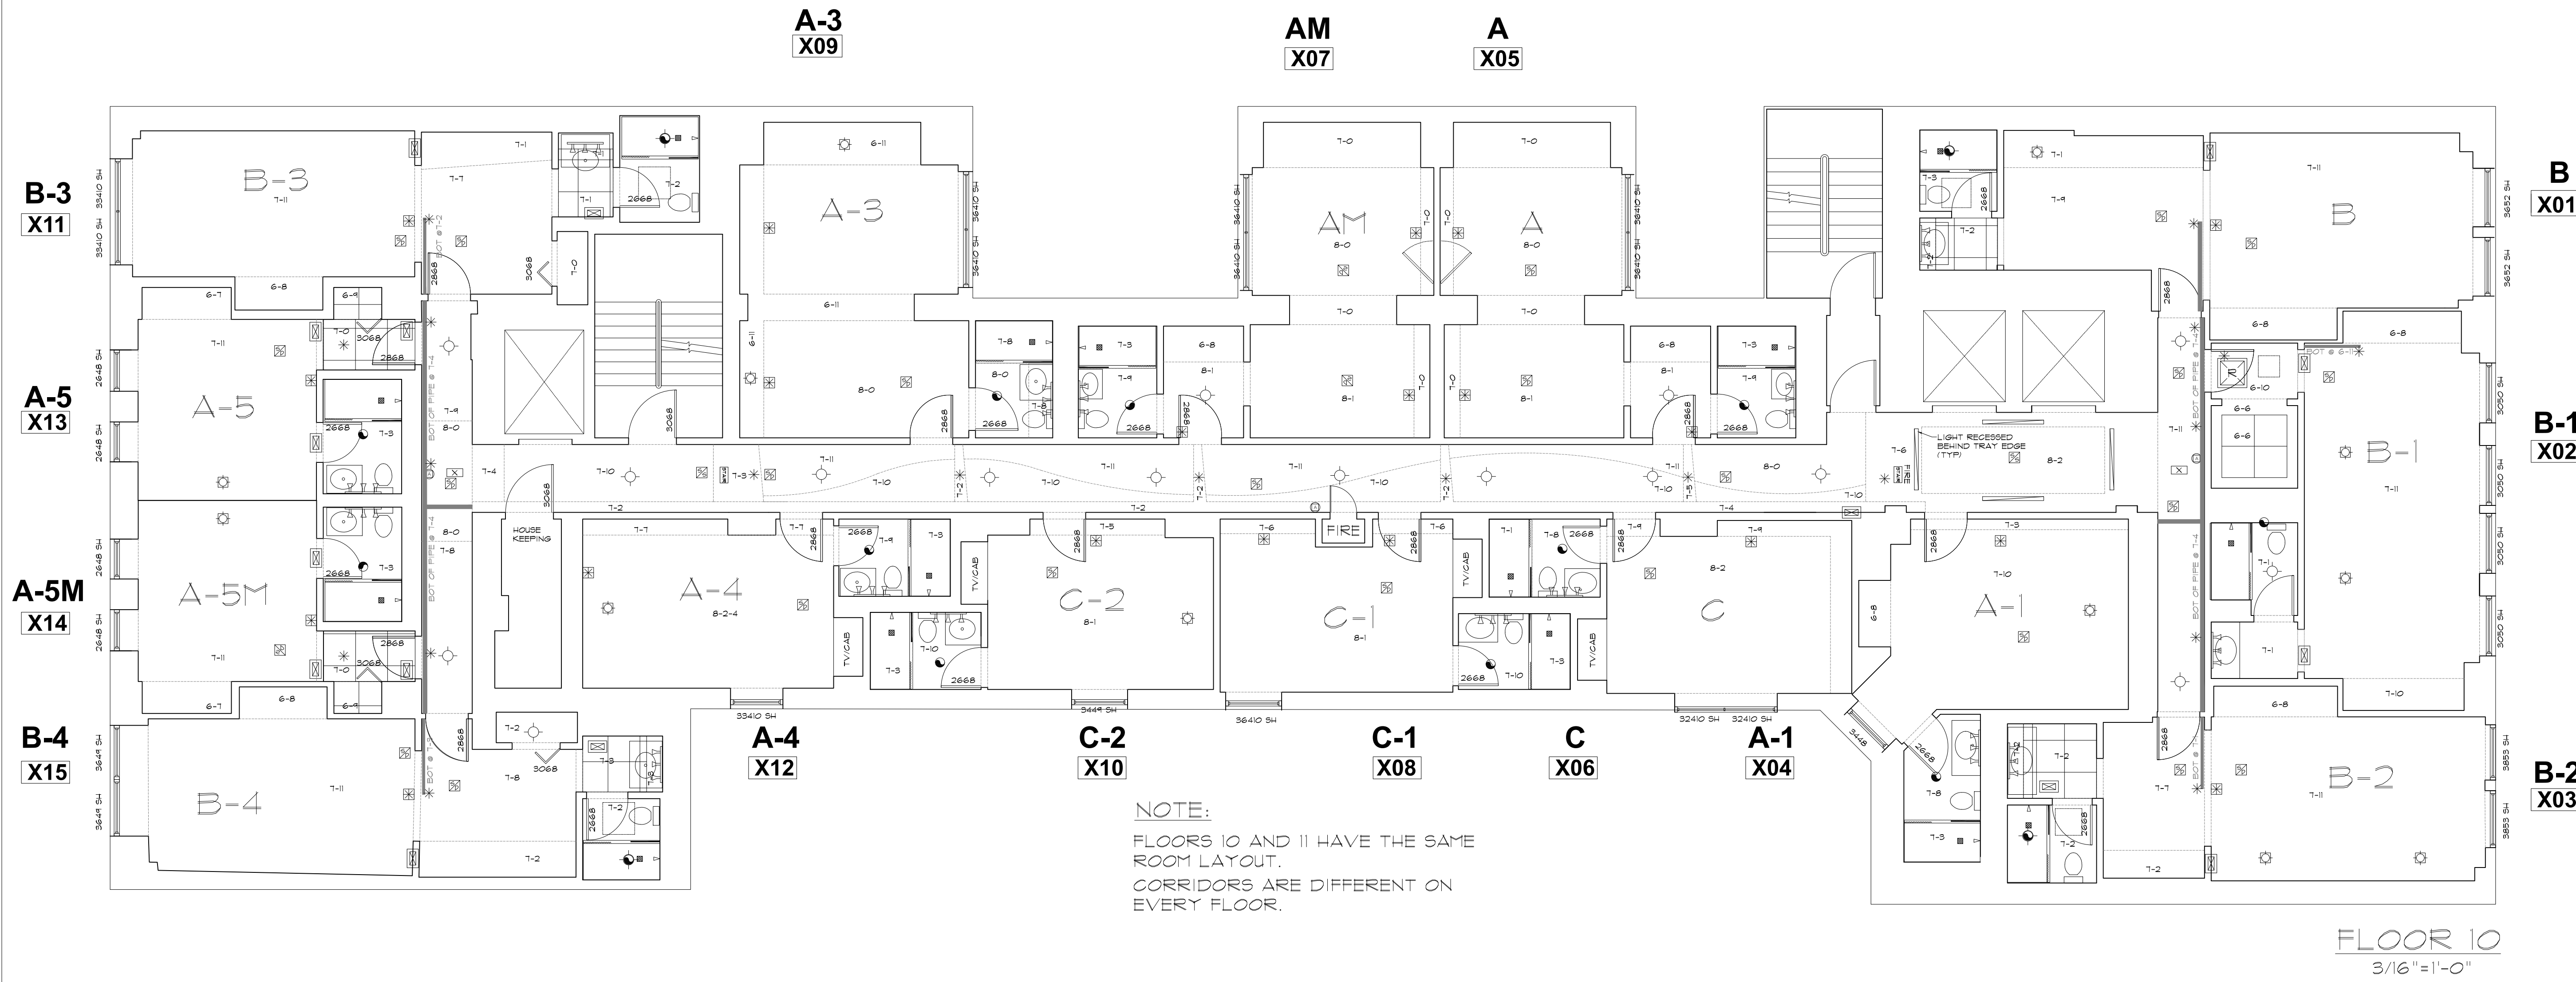

AS BUILT
PROFESSIONALS
A DIVISION OF:


AEC
CONSULTANTS INC
www.aecconsultantsinc.com
844.272.8458

© 2016 AEC CONSULTANTS INC

ARCHITECTURAL AS BUILT
HOTEL INDIGO
1244 N DEARBORN STREET CHICAGO, IL 60610

SYMBOLS LEGEND			
RCP		ELECTRIC	FIRE PROTECTION
	EXHAUST VENT		FIRE EXTINGUISHER
	CEILING MOUNTED LIGHT FIXTURE		FIRE PULL
	CEILING MOUNTED DIRECTIONAL LIGHT		FIRE ALARM (HORN/SRTOPE)
	RECESSED CAN LIGHT		SMOKE DETECTOR
	EYEBALL OR SMALL CAN LIGHT		SMOKE ALARM SPEAKER
	PENDANT LIGHT		SPRINKLER HEAD CEILING MOUNT
	INDIVIDUAL FLUOR. LAY-IN FIXTURE 4 BULB		SPRINKLER HEAD WALL MOUNT
	INDIVIDUAL FLUOR. HANGING FIXTURE 2 BULB		
	INDIVIDUAL FLUOR. FLUSH MOUNT FIXTURE 4 BULB		
	CAMERA		
	MOTION DET.		
	SUPPLY VENT		
	RETURN VENT		
	RETURN VENT		
	SPEAKER		

01	100% SUBMISSION	
NO.	ISSUES REVISIONS	DATE
SHEET TITLE		
HL	PROJECT MANAGER	
HL	PROJECT DIRECTOR	
9-2-16-1	PROJECT NUMBER	
AS NOTED	SCALE	
CL	DRAWN BY	
SHEET NUMBER		
AB-11		

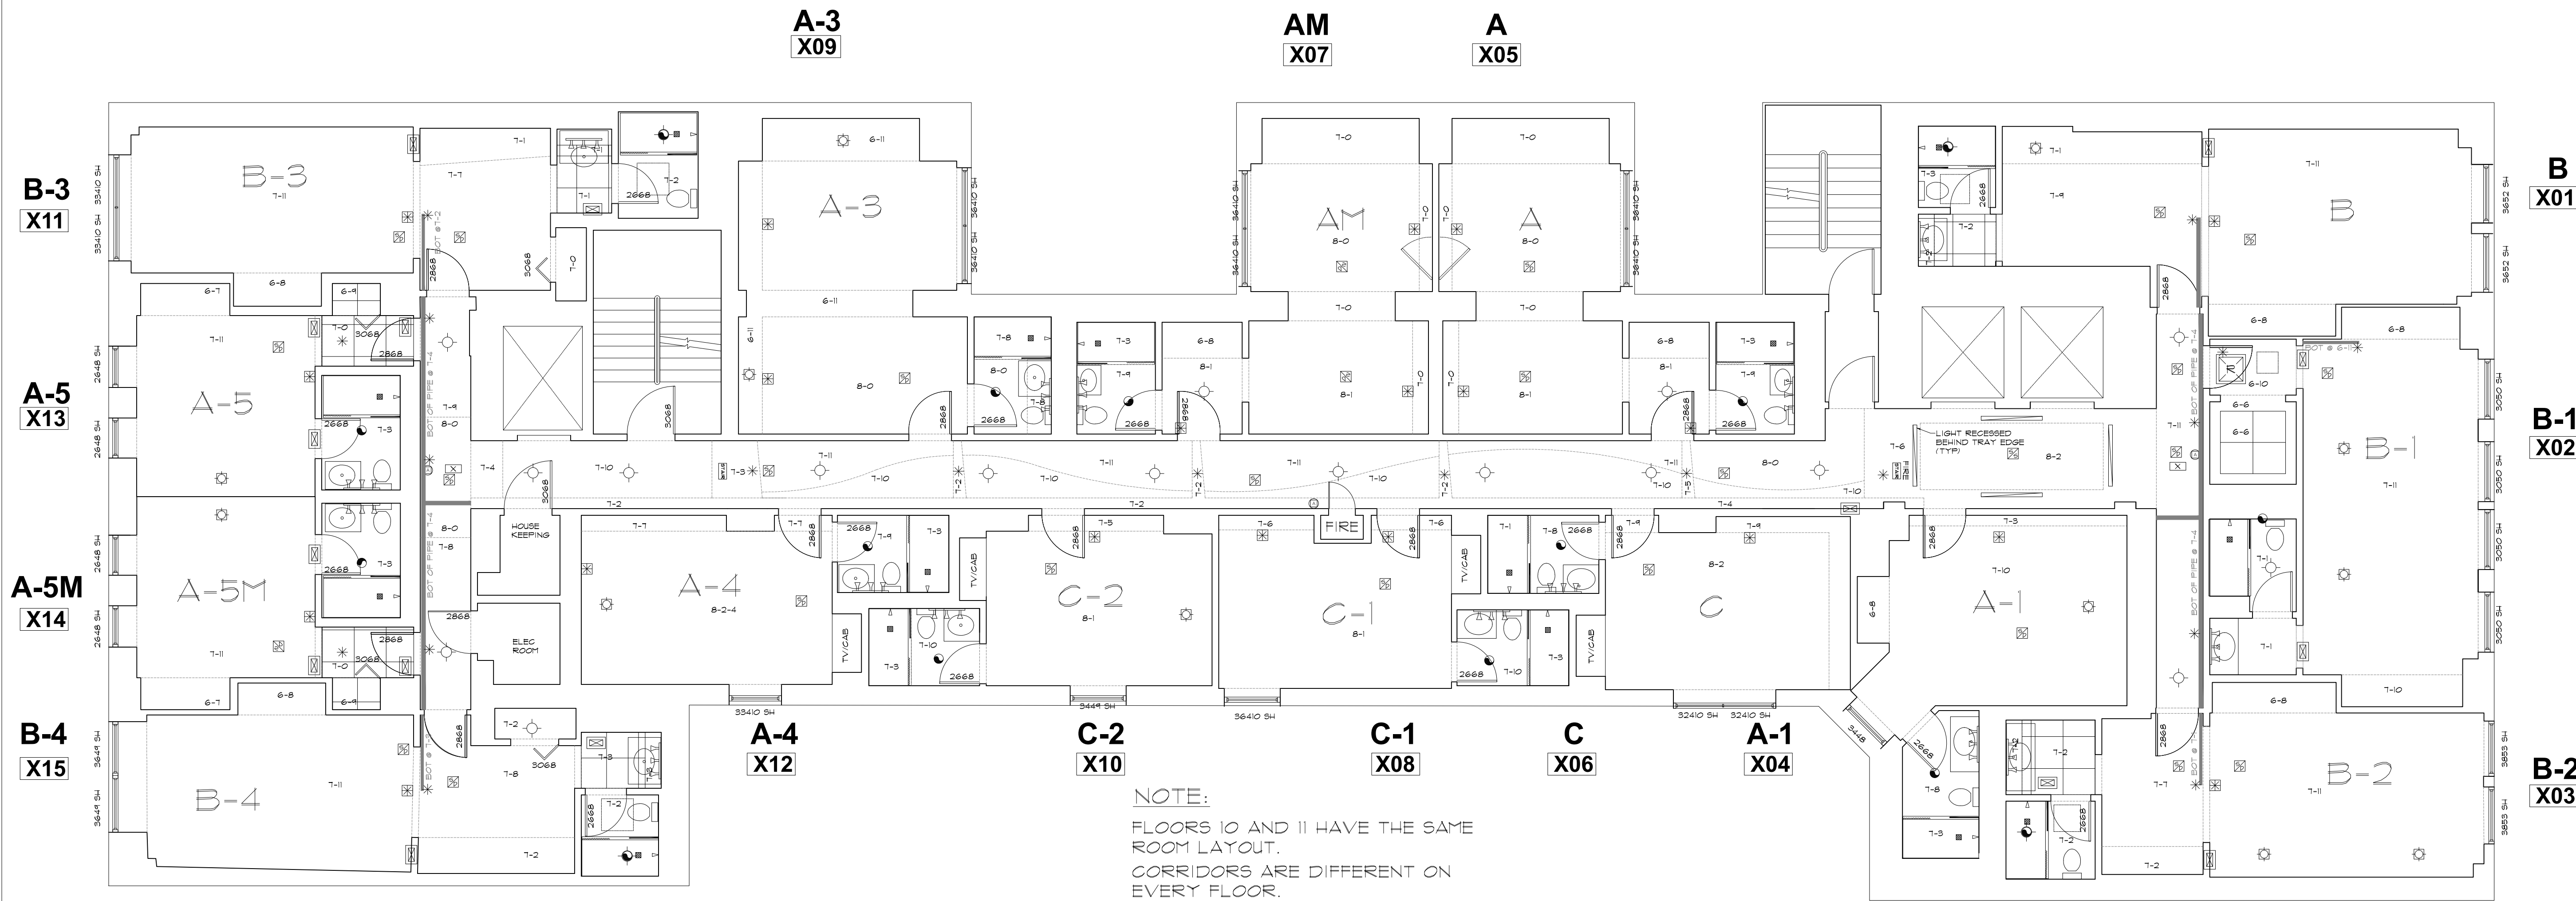

NOTE:
FLOORS 10 AND 11 HAVE THE SAME
ROOM LAYOUT.
CORRIDORS ARE DIFFERENT ON
EVERY FLOOR.

FLOOR 11
3/16"=1'-0"

SYMBOLS LEGEND

RCP

- EXHAUST VENT
- CEILING MOUNTED LIGHT FIXTURE
- CEILING MOUNTED DIRECTIONAL LIGHT
- RECESSED CAN LIGHT
- EYEBALL OR SMALL CAN LIGHT
- PENDANT LIGHT
- INDIVIDUAL FLUOR. LAY-IN FIXTURE 4 BULB
- INDIVIDUAL FLUOR. HANGING FIXTURE 2 BULB
- INDIVIDUAL FLUOR. FLUSH MOUNT FIXTURE 4 BULB
- CAMERA
- MOTION DET.
- SUPPLY VENT
- SUPPLY VENT
- RETURN VENT
- RETURN VENT
- SPEAKER

- TRACK LIGHT OR VANITY LIGHT
- WALL-MOUNTED LIGHT FIXTURE
- EMERGENCY EXIT SIGN
- EMERGENCY EXIT LIGHT
- EMERGENCY EXIT LIGHT W/ SIGN
- LIGHTED STAIR SIGN
- FLOOD LIGHT
- PHOTO CELL
- CEILING FAN
- CEILING FAN W/ LIGHT KIT
- CEILING HEIGHT AND TRIM 7'-2" ABOVE FLOOR BELOW WITH 6" CROWN MOULDING. NOTE: ALL CEILINGS NOT LABELED ARE PLASTER CEILINGS SHOWN WITH A GRID ARE LAY IN ACOUSTICAL TILE..
- JUNCTION BOX

ELECTRIC

- DATA OUTLET
- TELEPHONE JACK
- ELECTRIC SWITCH
- CABLE TELEVISION OUTLET
- DUPLEX RECEPTACLE OUTLET
- SPECIAL PURPOSE CONNECTION OR OUTLET
- QUADRUPEX RECEPTACLE OUTLET
- FLOOR DUPLEX RECEPTACLE OUTLET
- ELECTRIC PANEL
- ELECTRIC METER
- BUTTON SWITCH
- DISCONNECT SWITCH
- GROUND/FLOOR LIGHT
- KEY PAD

FIRE PROTECTION

- FIRE EXTINGUISHER
- FIRE PULL
- FIRE ALARM (HORN/SRTOKE)
- SMOKE DETECTOR
- SMOKE ALARM SPEAKER
- SPRINKLER HEAD CEILING MOUNT
- SPRINKLER HEAD WALL MOUNT

MEP

- THERMOSTAT
- FLOOR DRAIN
- VALVE
- HOSE BIB
- WATER SUPPLY
- SUSPENDED GAS HEATER


MISC

- BOLLARD



ARCHITECTURAL AS BUILT
HOTEL INDIGO
1244 N DEARBORN STREET CHICAGO, IL 60610

01	100% SUBMISSION	
NO.	ISSUES REVISIONS	DATE
SHEET TITLE		
HL	PROJECT MANAGER	
HL	PROJECT DIRECTOR	
9-2-16-1	PROJECT NUMBER	
AS NOTED	SCALE	
	DRAWN BY	
CL		
SHEET NUMBER		
AB-12		

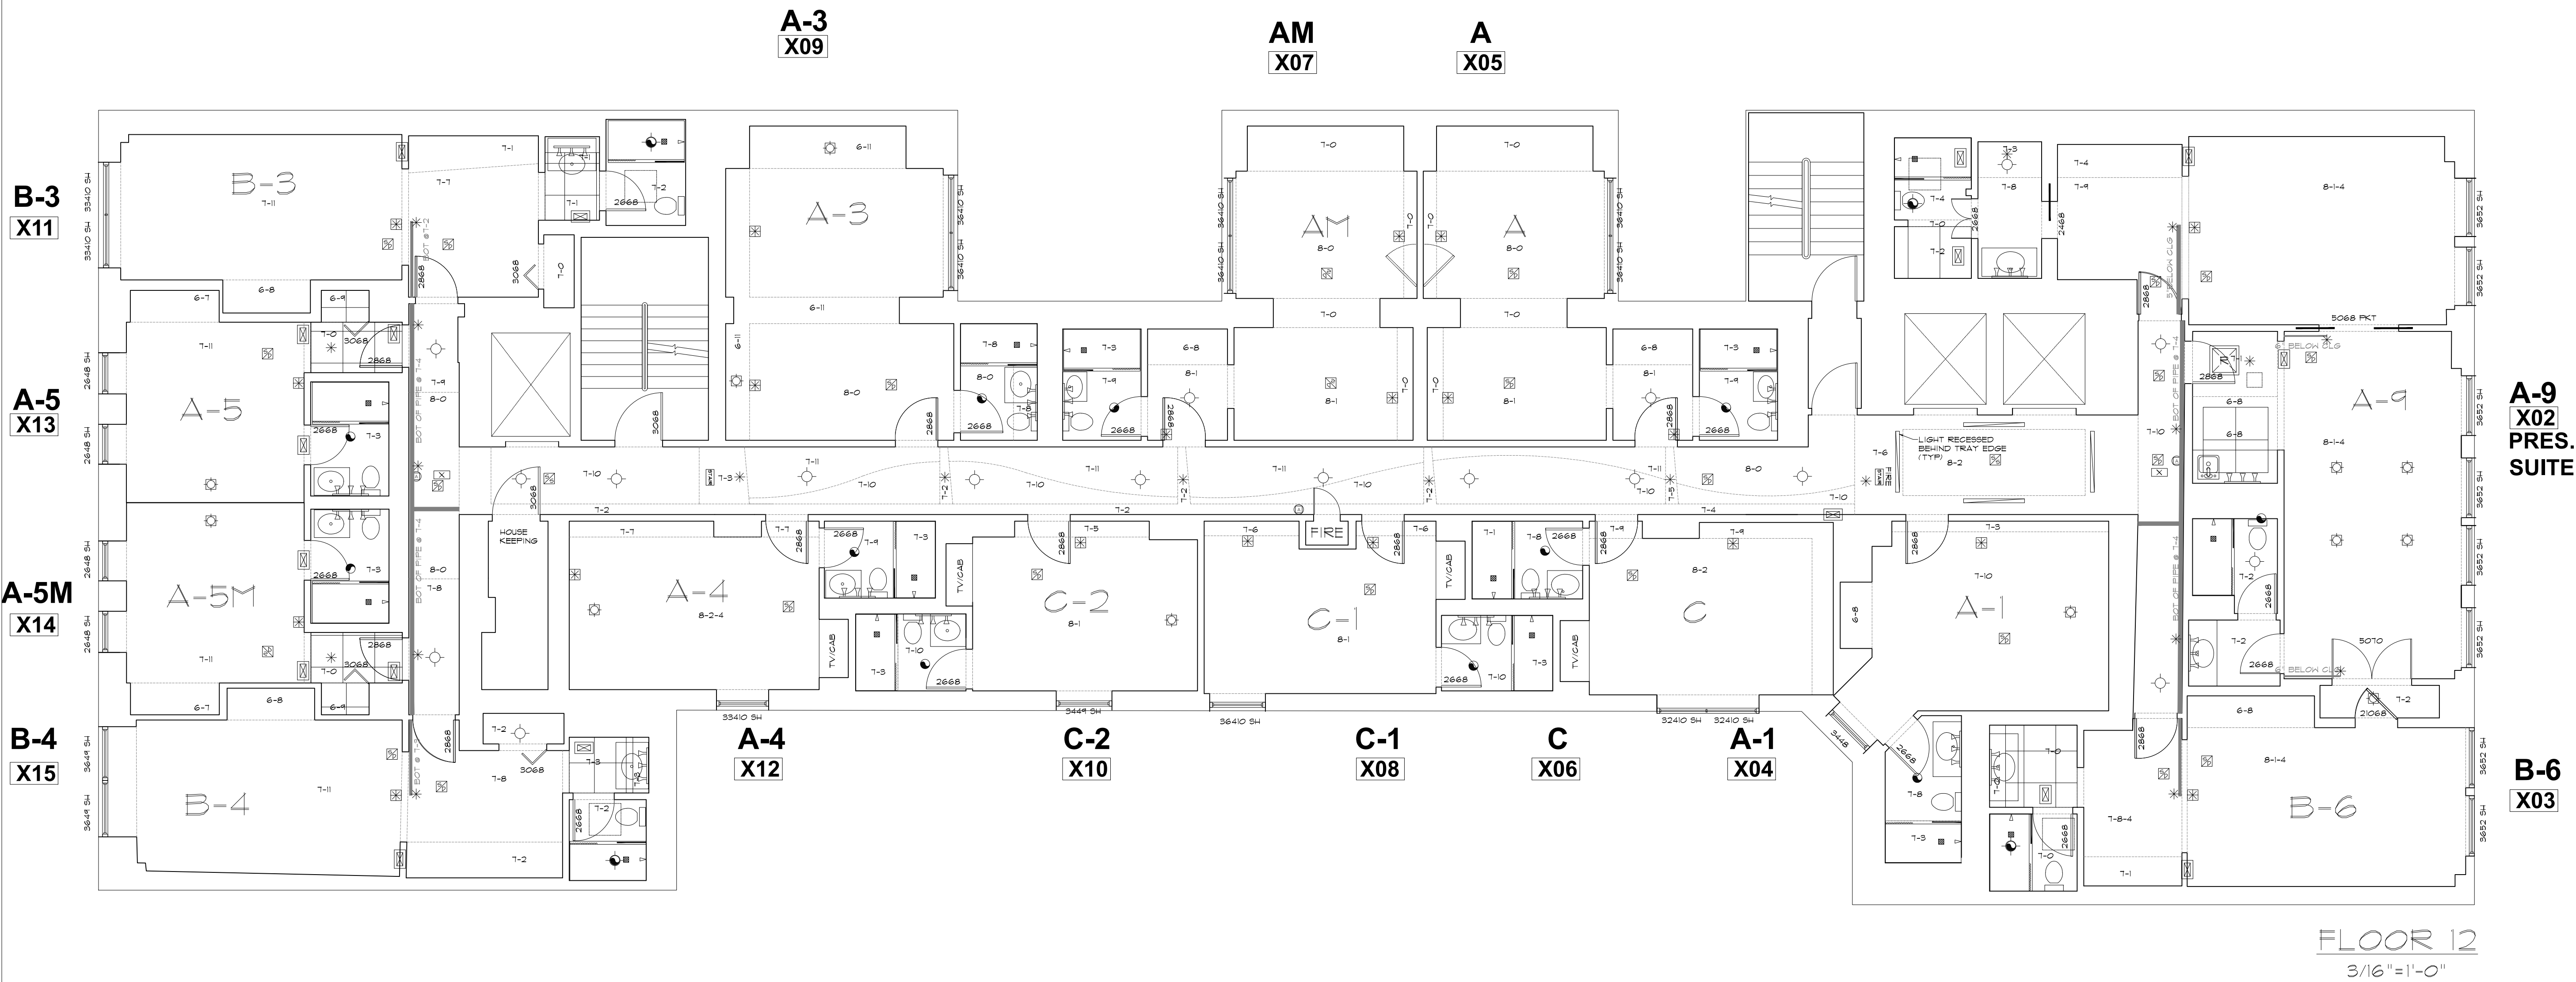

A-9
X02
PRES.
SUITE

B-6
X03

AS BUILT
PROFESSIONALS
A DIVISION OF:

AEC
CONSULTANTS INC
www.aecconsultantsinc.com
844.272.8458

© 2016 AEC CONSULTANTS INC

ARCHITECTURAL AS BUILT
HOTEL INDIGO
1244 N DEARBORN STREET CHICAGO, IL 60610

SYMBOLS LEGEND

RCP		ELECTRIC		FIRE PROTECTION	
	EXHAUST VENT		TRACK LIGHT OR VANITY LIGHT		FIRE EXTINGUISHER
	CEILING MOUNTED LIGHT FIXTURE		WALL-MOUNTED LIGHT FIXTURE		FIRE PULL
	CEILING MOUNTED DIRECTIONAL LIGHT		EMERGENCY EXIT SIGN		FIRE ALARM (HORN/SRTO)
	RECESSED CAN LIGHT		EMERGENCY EXIT LIGHT		SMOKE DETECTOR
	EYEBALL OR SMALL CAN LIGHT		EMERGENCY EXIT LIGHT W/ SIGN		SMOKE ALARM SPEAKER
	PENDANT LIGHT		LIGHTED STAIR SIGN		SPRINKLER HEAD CEILING MOUNT
	INDIVIDUAL FLUOR. LAY-IN FIXTURE 4 BULB		FLOOD LIGHT		SPRINKLER HEAD WALL MOUNT
	INDIVIDUAL FLUOR. HANGING FIXTURE 2 BULB		PHOTO CELL	MEP	
	INDIVIDUAL FLUOR. FLUSH MOUNT FIXTURE 4 BULB		CEILING FAN		
	CAMERA		CEILING FAN W/ LIGHT KIT		
	MOTION DET.		7-2-6 CEILING HEIGHT AND TRIM 7'-2" ABOVE FLOOR BELOW 6" CROWN MOLDING. NOTE: ALL CEILINGS NOT LABELED ARE PLASTER CEILINGS SHOWN WITH A GRID ARE LAY IN ACOUSTICAL TILE..		
	SUPPLY VENT		JUNCTION BOX	MISC	
	RETURN VENT				
	RETURN VENT				
	SPEAKER				
					THERMOSTAT
					FLOOR DRAIN
					VALVE
					HOSE BIB
					WATER SUPPLY
					SUSPENDED GAS HEATER
					KEY PAD
					BOLLARD

01	100% SUBMISSION	
NO.	ISSUES REVISIONS	DATE
SHEET TITLE		
HL	PROJECT MANAGER	
HL	PROJECT DIRECTOR	
9-2-16-1	PROJECT NUMBER	
AS NOTED	SCALE	
CL	DRAWN BY	
SHEET NUMBER		

AB-13

